



**PROCUREMENT SERVICES
ADDENDUM**

Date of Notice:	1/27/2025
Solicitation No.:	IB-010-25
Title:	HSC Restroom Renovations
Addendum No.:	2

The following pages shall clarify and/or modify the original bid document(s) as issued by the University of Louisville.

The due date for this bid has been extended to **2/4/2025 at 3:00PM, EST.**

Proposer must acknowledge receipt of this and any addenda either with proposal or by separate letter. Acknowledgement must be received in the Department of Procurement Services, Service Complex Building, University of Louisville no later than **2/4/2025 at 3:00PM, EST.** If by separate letter, the following information must be placed in the lower left-hand corner of the envelope:

Solicitation No.:	IB-010-25
Title:	HSC Restroom Renovations
Due Date:	2/4/2025 at 3:00PM, EST.

Authorized By:

Procurement Services	
-------------------------	--

Receipt Acknowledged:

Company	
Signature	
Name (print)	
Date	

1. On sheet E100, keynote E4 says to provide new police call sounder station and tie into existing system. Coordinate exact requirements with UofL. Our electrical sub is asking where these are supplied from. They are wanting to make sure that they quote the ones that UofL requires.

University Response: Please see the below attached drawings.

REVISIONS		
#	DATE	DESCRIPTION
2	1/27/25	ADDENDUM 2



PROJECT TEAM

EOP ARCHITECTS
PRIME ARCHITECT
322 EAST MAIN STREET
LOUISVILLE, KY 40202
p. 859-231-7538 | f. 859-255-4380
www.eopa.com

CMTA, INC.
10411 MEETING STREET
PROSPECT, KY 40059
p. 502-328-3085
www.cmta.com

GENERAL NOTES (ELECTRICAL NEW WORK):

- A. REFER TO THE ARCHITECT'S REFLECTED CEILING PLANS, ELEVATIONS, AND CASEWORK DETAILS FOR EXACT LOCATIONS OF ALL WALL AND CEILING MOUNTED ELECTRICAL DEVICES.
- B. CONTRACTOR SHALL FOLLOW BRANCH CIRCUITING LAY-OUT, AS INDICATED ON THE FLOOR PLANS, WITH A MAXIMUM OF THREE (3) BRANCH CIRCUITS PER HOMERUN. EACH BRANCH CIRCUIT SHALL BE PROVIDED WITH A DEDICATED NEUTRAL CONDUCTOR. DEDICATED NEUTRAL CONDUCTORS SHALL BE CONSIDERED CURRENT CARRYING. IF ADDITIONAL CONDUCTORS ARE RAN IN THE SAME CONDUIT WITH THOSE INDICATED, CONTRACTOR SHALL DERATE ALL CURRENT CARRYING CONDUCTORS PER N.E.C. #310.15(B)(3), AND UPSIZE CONDUIT AS REQUIRED PER N.E.C. #300.17 AND ANNEX C. MULTIWIRE BRANCH CIRCUITS AS DEFINED IN N.E.C. #100.210.4 (CIRCUITS SHARING A COMMON NEUTRAL CONDUCTOR) SHALL NOT BE PERMITTED.
- C. IDENTIFY THE PANEL AND CIRCUIT NUMBER FOR ALL RECEPTACLES, SWITCHES, ETC. IN AREA OF CONSTRUCTION. PROVIDE CLEAR ADHESIVE LABELS WITH BLACK LETTERING; ALSO, MARK INSIDES OF ALL DEVICE BOXES WITH PANEL AND CIRCUIT NUMBER.
- D. LOCATE CHAIN-HUNG INDUSTRIAL FIXTURES IN MECHANICAL ROOMS TO AVOID DUCTWORK AND PIPING. TO MAXIMIZE AVAILABLE LIGHT SPACE AROUND EQUIPMENT, AIR HANDLERS, ETC. TO PROVIDE ADEQUATE LIGHTING TO ALL AREAS OF ROOM. PROVIDE ADDITIONAL FIXTURES OF SAME TYPE AS NEEDED TO FULFILL THIS REQUIREMENT.
- E. LOCATE EXIT SIGNS FOR MAXIMUM VIEWING AREA TO IDENTIFY EGRESS PATHS AS INDICATED ON PLANS. COORDINATE LOCATIONS SUCH THAT ARCHITECTURAL FEATURES OR EQUIPMENT FROM OTHER TRADES DO NOT OBSTRUCT VIEW.
- F. ALL LIGHTING FIXTURE LENSES, PARABOLIC LOUVERS, DOWNLIGHTING ALZAK CONES AND "PARACUBE" LOUVERS SHALL BE HANDLED WITH COTTON GLOVES DURING INSTALLATION AND LAMPING TO AVOID FINGERPRINTS OR DIRT DEPOSITS. IT IS PREFERRED THAT FIXTURES BE SHIPPED AND INSTALLED WITH CLEAR PLASTIC BAGS TO PROTECT LOUVERS. AT CLOSE OF PROJECT, AND AFTER CONSTRUCTION AIR FILTERS ARE CHANGED, REMOVE BAGS. ANY LOUVER OR CONE SHOWING DIRT OR FINGERPRINTS SHALL BE CLEANED WITH SOLVENT RECOMMENDED BY THE MANUFACTURER, OR REPLACED AS NECESSARY IN ORDER TO TURN OVER TO THE OWNER NEW FIXTURES AT OCCUPANCY.
- G. RECESSED LUMINAIRES SHALL BE SECURED SUCH THAT THE FORCE REQUIRED INSERTING LAMPS, TRIMS, LENSES, LOUVERS, OR DOOR FRAMES DOES NOT SHIFT HOUSING. ALL TRIMS SHALL BE COMPLETELY FLUSH WITH FINISHED CEILINGS AT COMPLETION OF CONSTRUCTION.
- H. CONTRACTOR SHALL PROVIDE UNSWITCHED CONDUCTOR TO ALL EXIT SIGNS, EMERGENCY INVERTER BATTERY PACKS, AND NIGHT LIGHTS AS REQUIRED.
- I. RECEPTACLES THAT ARE CONTROLLED BY AN AUTOMATIC MEANS SUCH AS OCCUPANCY SENSOR OR ENERGY MANAGEMENT SYSTEM SHALL BE MARKED IN ACCORDANCE WITH NEC 408.3(E).
- J. LOCATIONS OF ELECTRICAL CONNECTIONS AND LOCAL DISCONNECTS SHALL BE COORDINATED WITH MECHANICAL AND PLUMBING CONTRACTORS TO ENSURE ACCESS AND WORKING CLEARANCE IS MAINTAINED PER NEC. NOTIFY OTHER TRADES OF REQUIRED CLEARANCE AREAS TO AVOID ROUTING OF OTHER SYSTEMS IN THESE AREAS. DO NOT INSTALL ELECTRICAL EQUIPMENT OVER EQUIPMENT NAMEPLATES OR ACCESS PANELS OR THROUGH ACCESS/MAINTENANCE CLEARANCES OF EQUIPMENT BY OTHER TRADES.
- K. EXISTING TO REMAIN DEVICES/FACEPLATES SHALL BE REPLACED AS NECESSARY FOR NEW ARCHITECTUAL FINISHES.

ELECTRICAL KEYNOTES



- E1 ROUTE # OF #12 CONDUCTORS IN 3/4" CONDUIT TO EXISTING RECEPTACLE CIRCUIT SERVING THIS AREA.
- E2 ROUTE # OF #12 CONDUCTORS IN 3/4" CONDUIT TO EXISTING LIGHTING CIRCUIT SERVING THIS AREA.
- E3 PROVIDE NEW BACKBOX, AND RACEWAY WITH PULLSTRING TO NEW POLICE CALL PULL STATION. COORDINATE EXACT REQUIREMENTS WITH UOFL.
- E4 PROVIDE NEW BACKBOX, AND RACEWAY WITH PULLSTRING TO NEW POLICE CALL SOUNDER STATION LOCATION. COORDINATE EXACT REQUIREMENTS WITH UOFL.

All designs, arrangements and plans indicated or represented by this drawing are the property of EOP Architects and were created and developed for use on and in connection with the specified project.


None of this information shall be used by or disclosed to any person or entity for any reason whatsoever without the permission of EOP Architects.

Written dimensions shall have precedence over scale dimensions. Contractor shall verify and be responsible for all dimensions and conditions on the job. Notify EOP Architects immediately of any variation from the dimensions and conditions shown by these drawings.


Job Number 497-8933
Drawn By ZTS
Checked By DDY
Date 2024/12/18

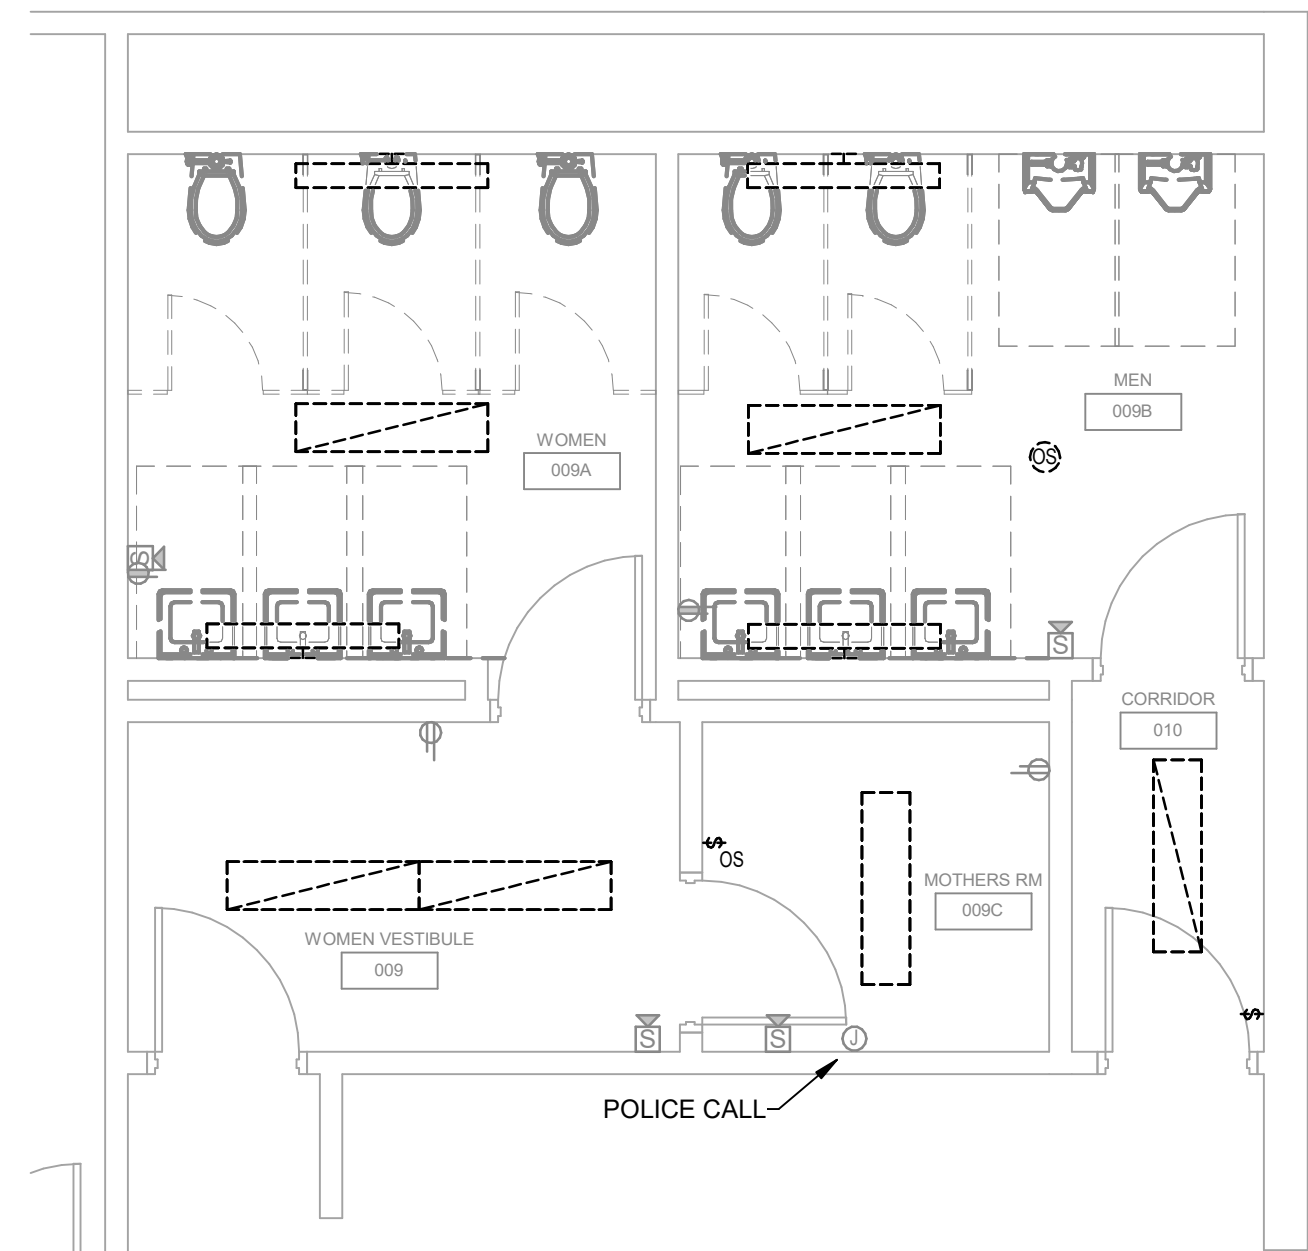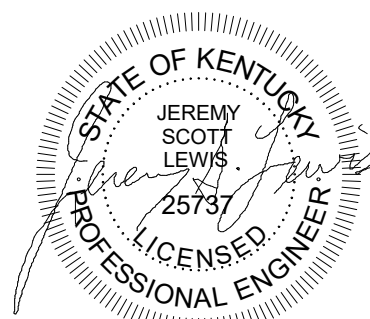


1 55B - BASEMENT RESTROOM - ELEC DEMO
1/4" = 1'-0"

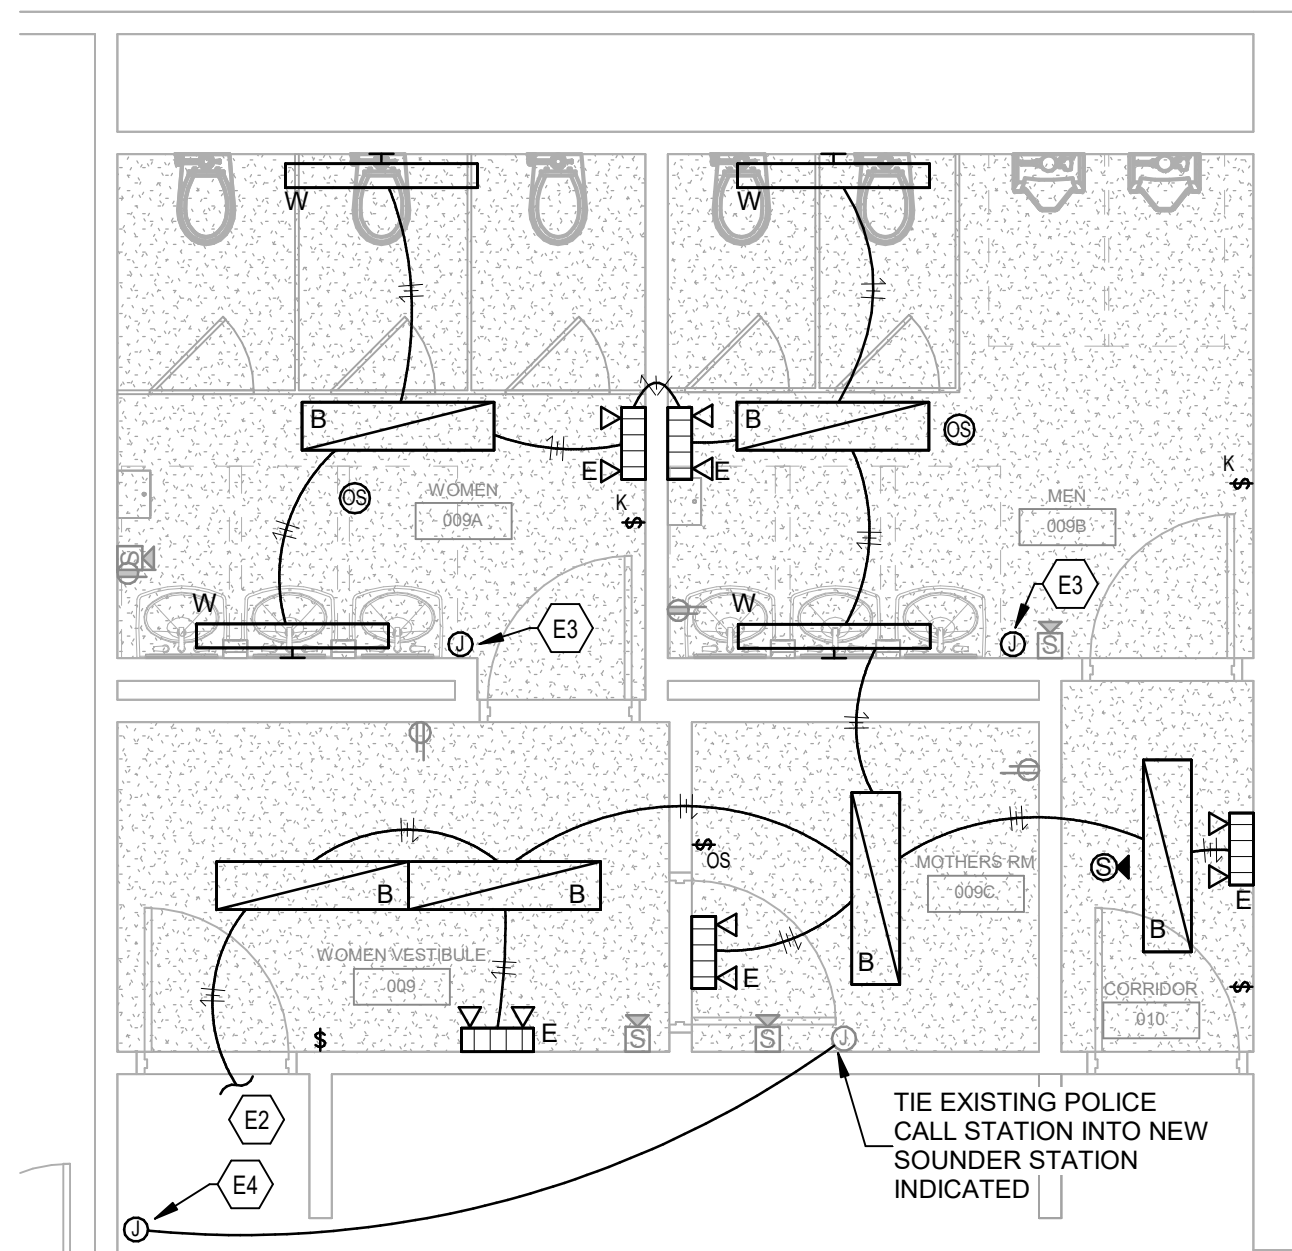


2 55B - BASEMENT RESTROOM - ELEC NEW
1/4" = 1'-0"

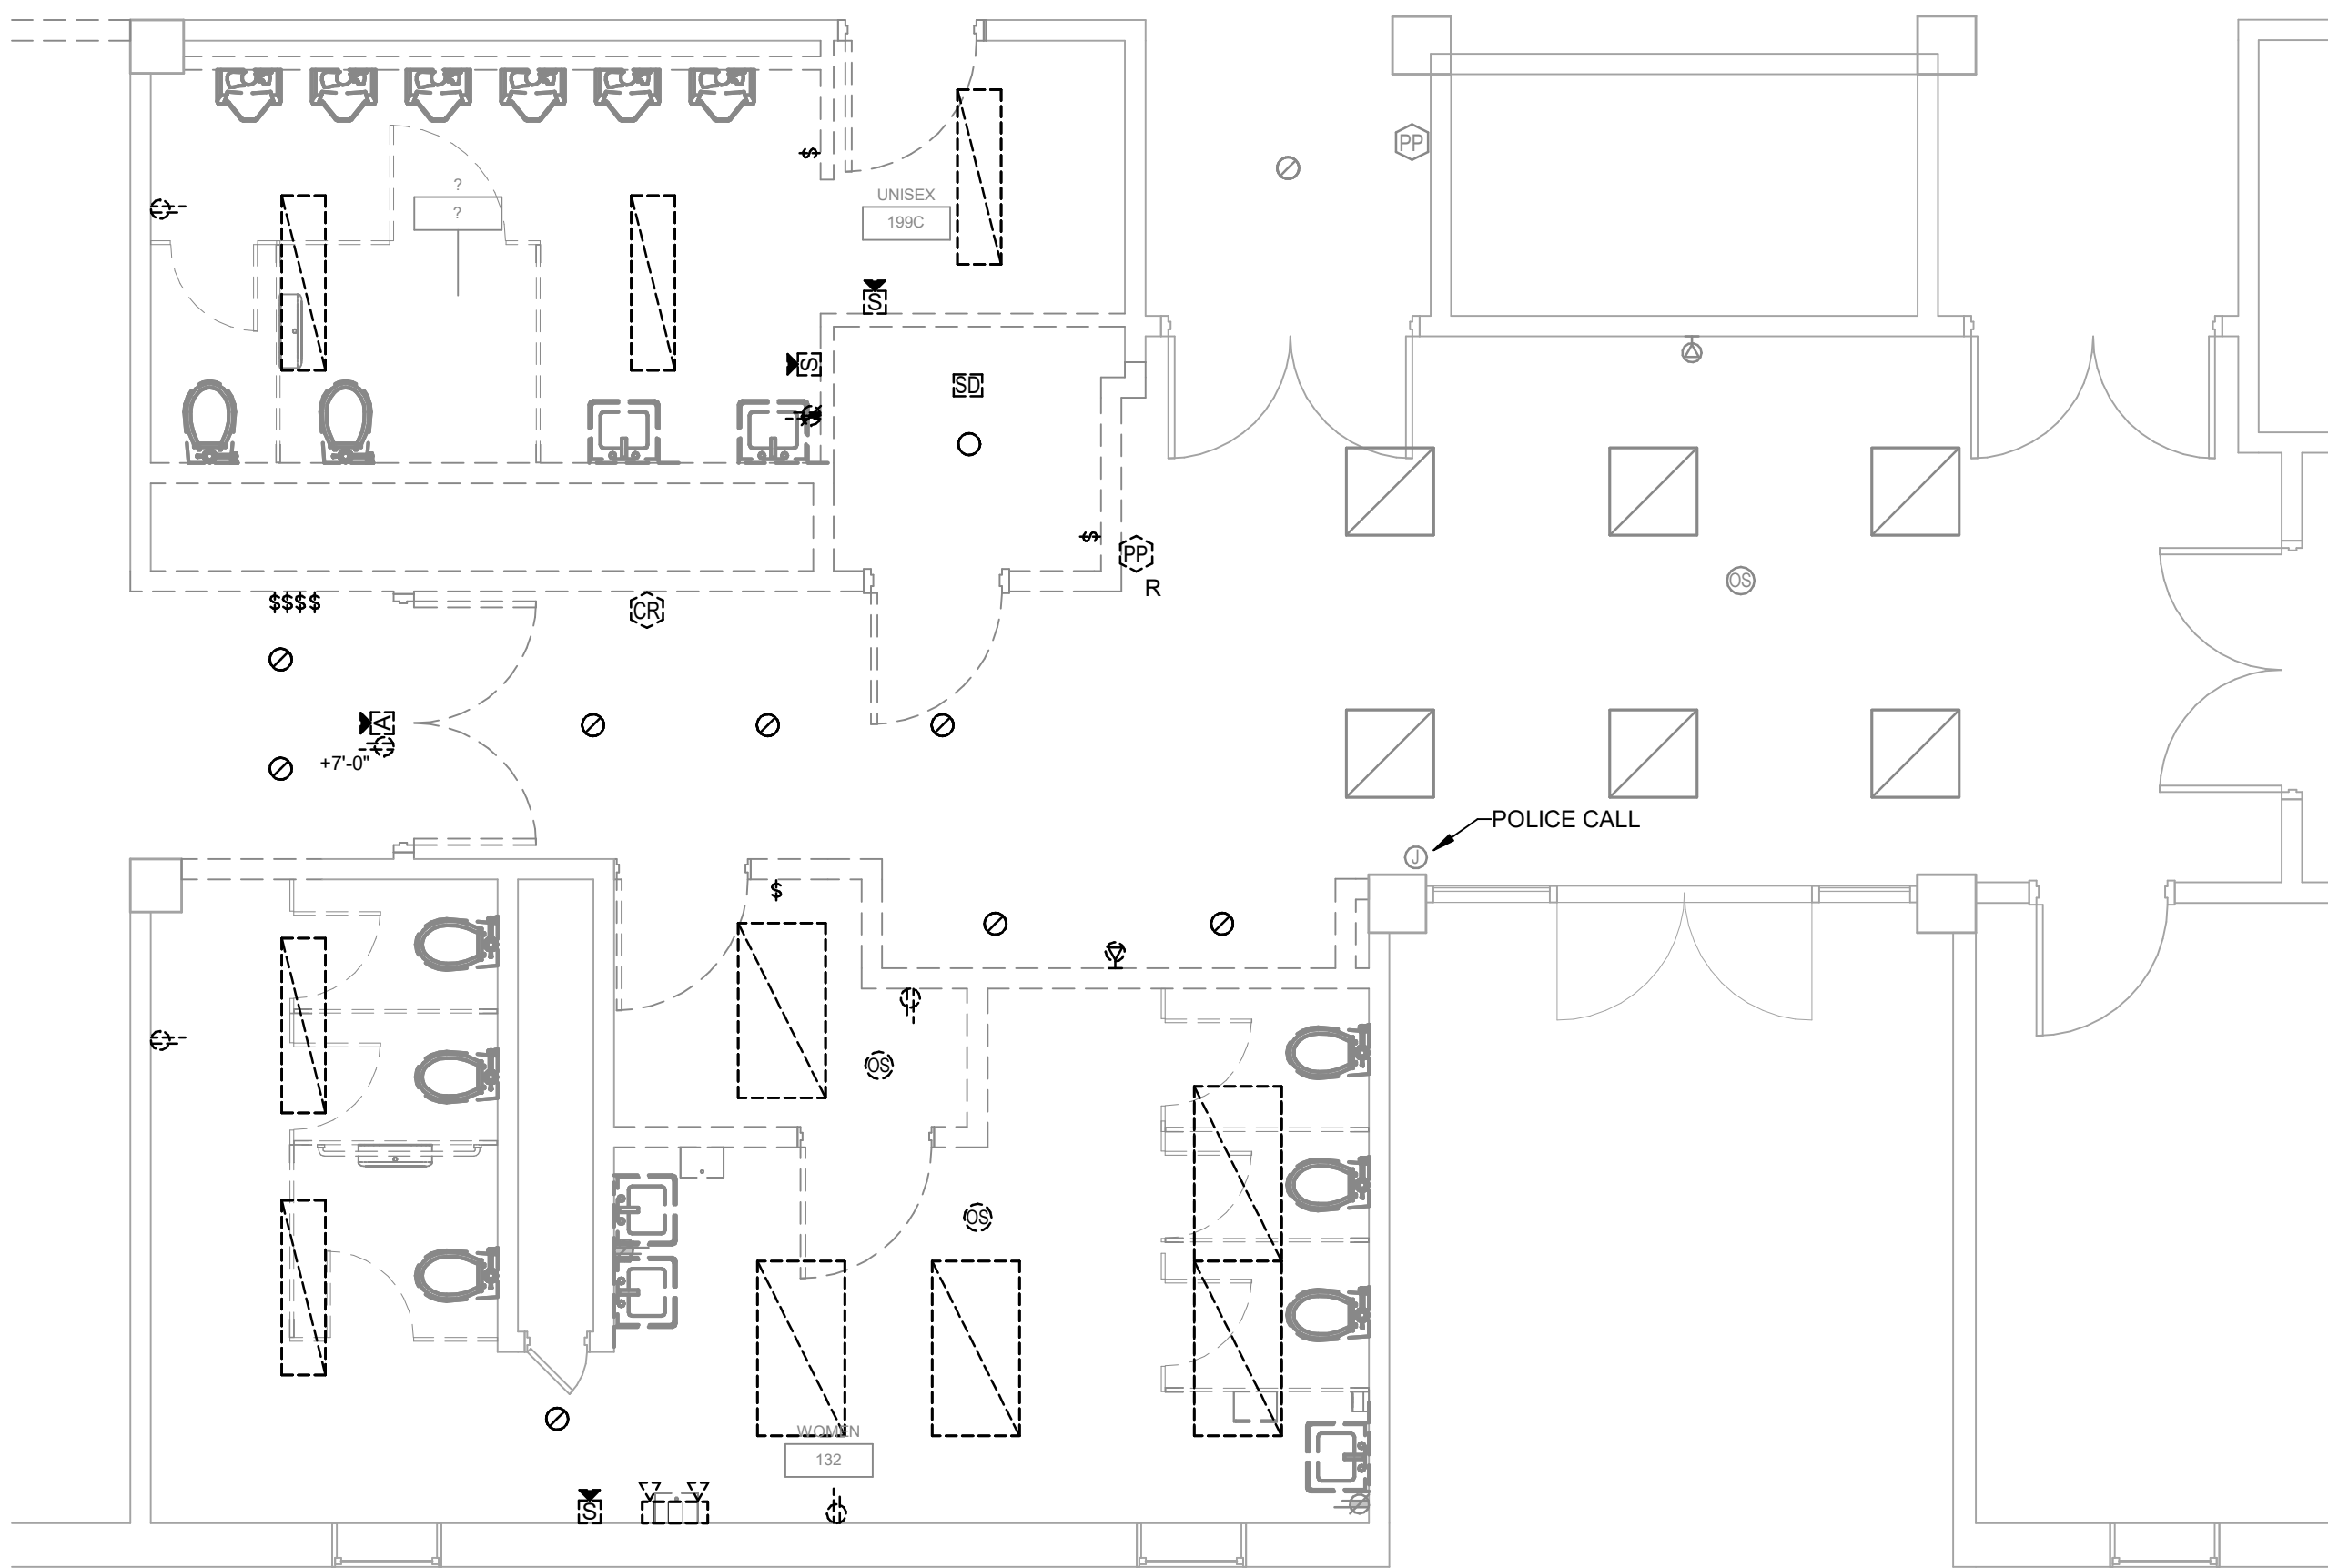


3 55B - FIRST FLOOR RESTROOMS - ELEC DEMO
1/4" = 1'-0"

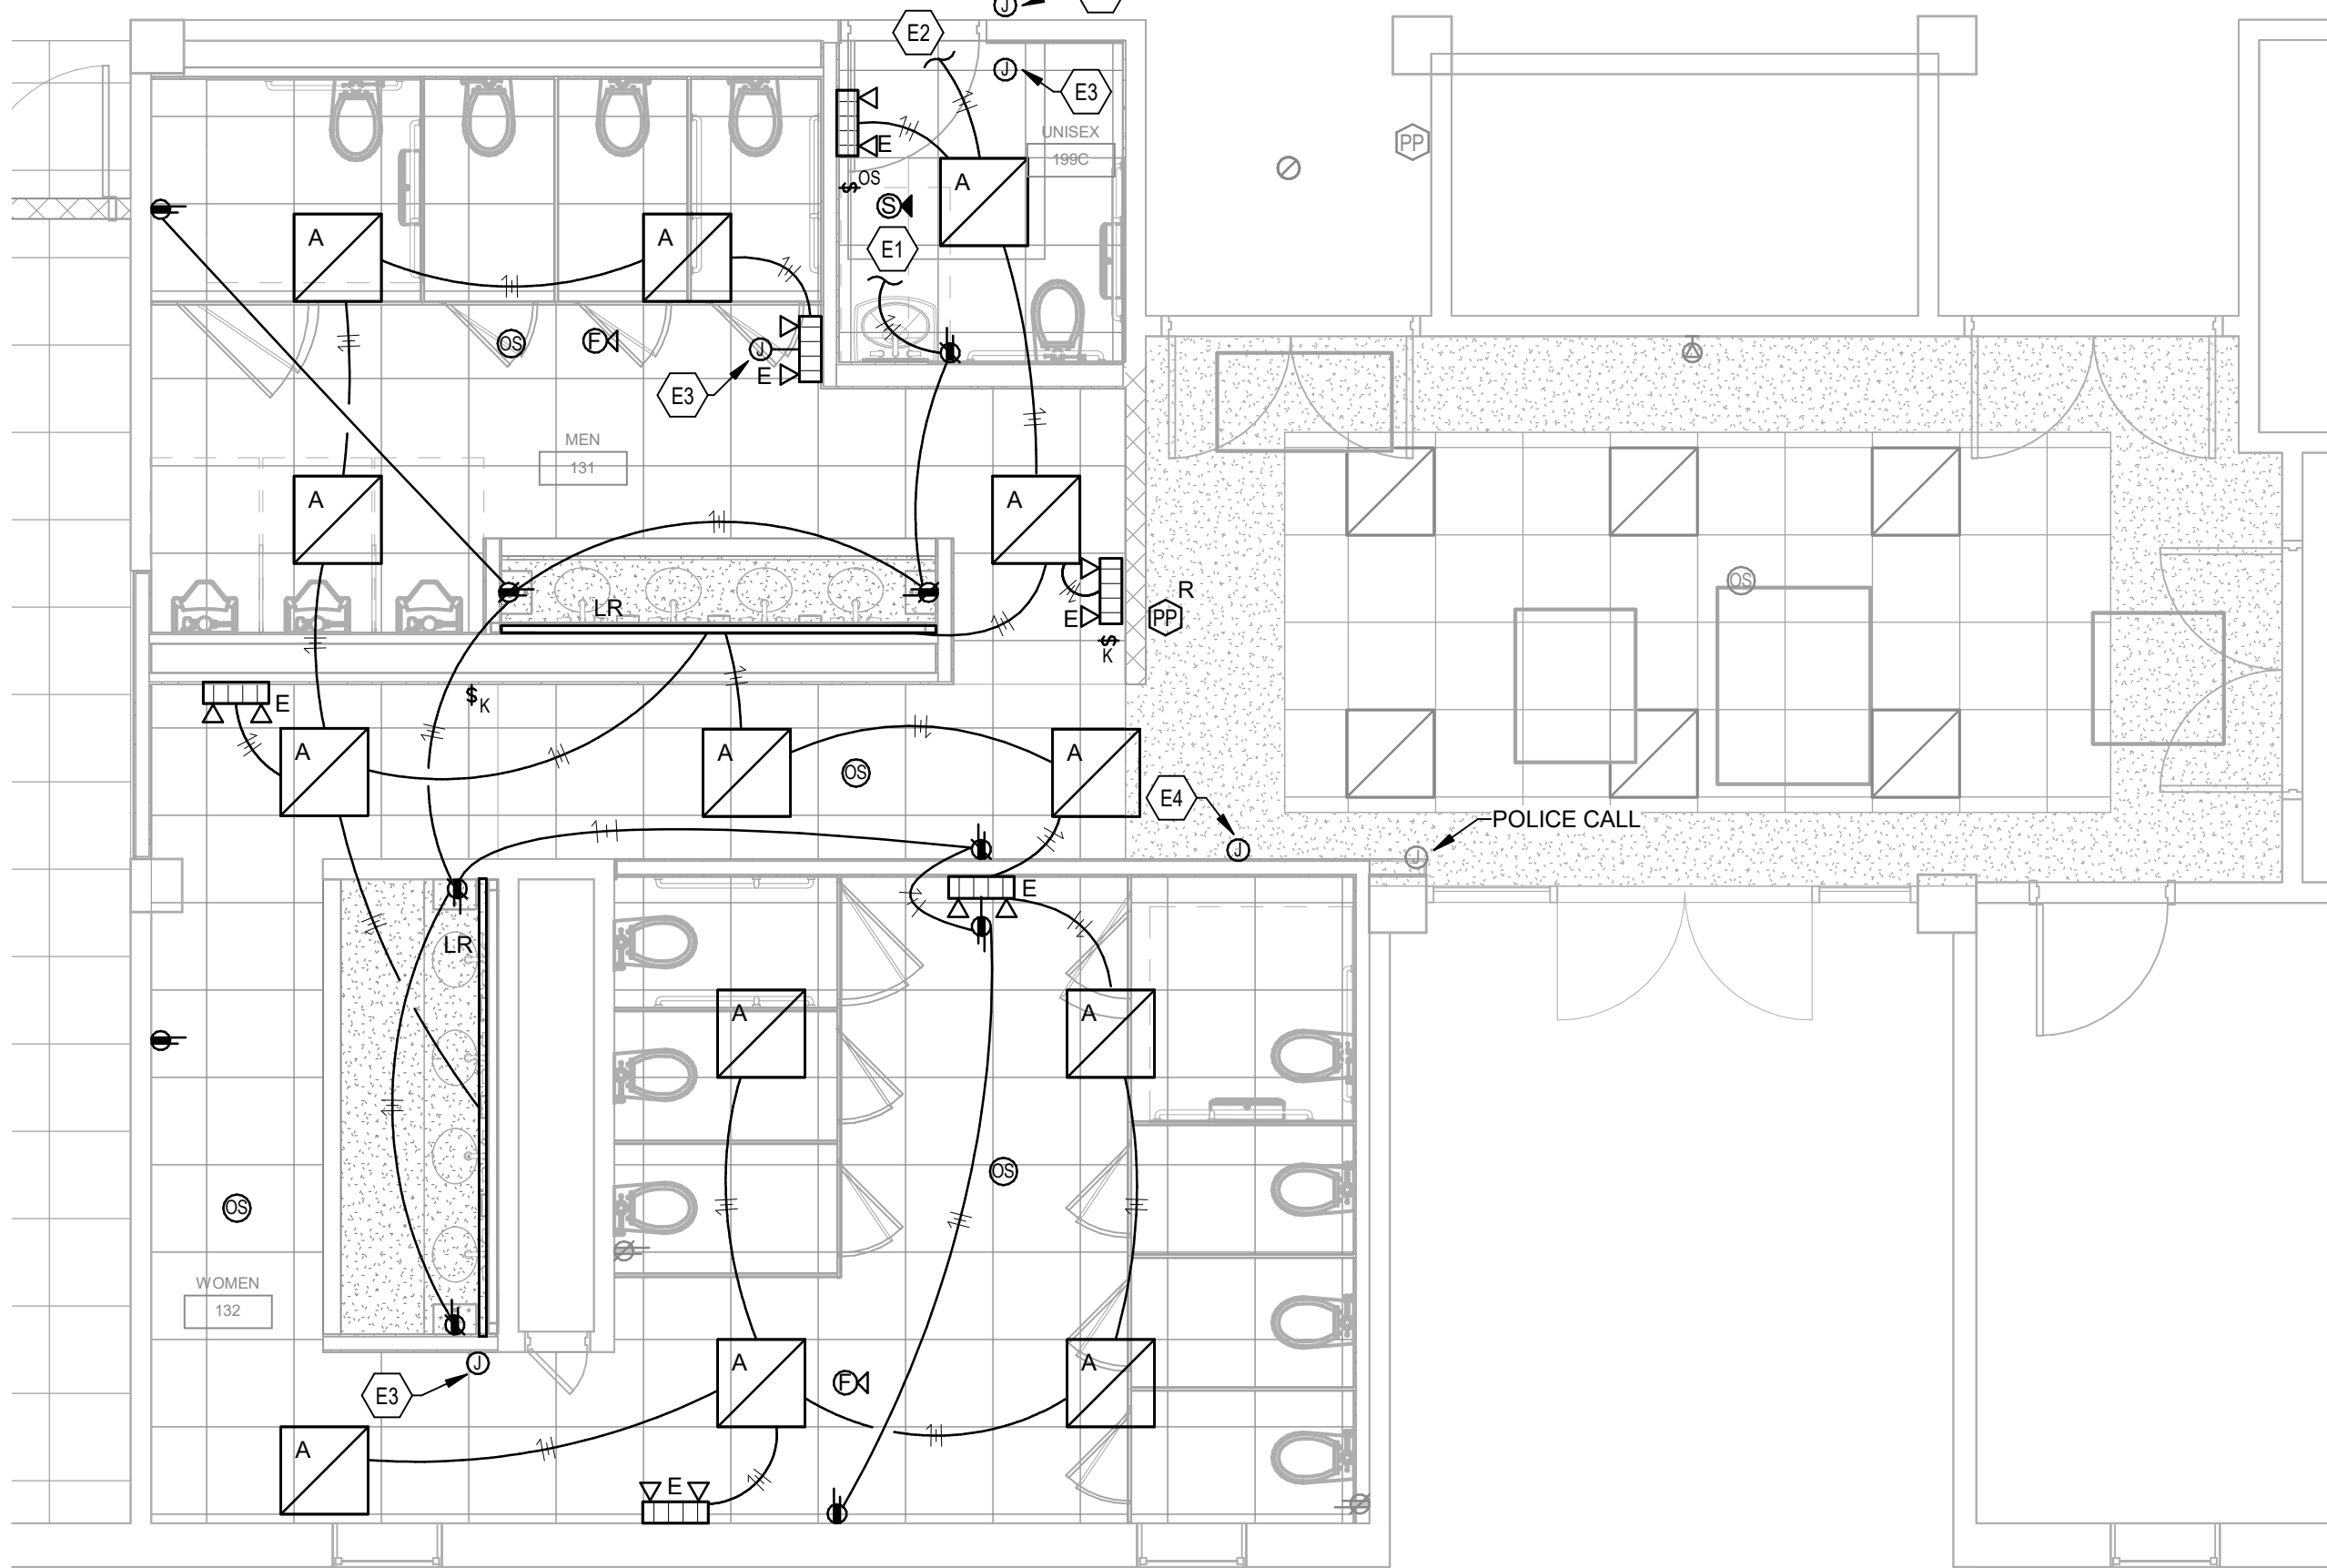


4 55B - FIRST FLOOR RESTROOMS - ELEC NEW
1/4" = 1'-0"

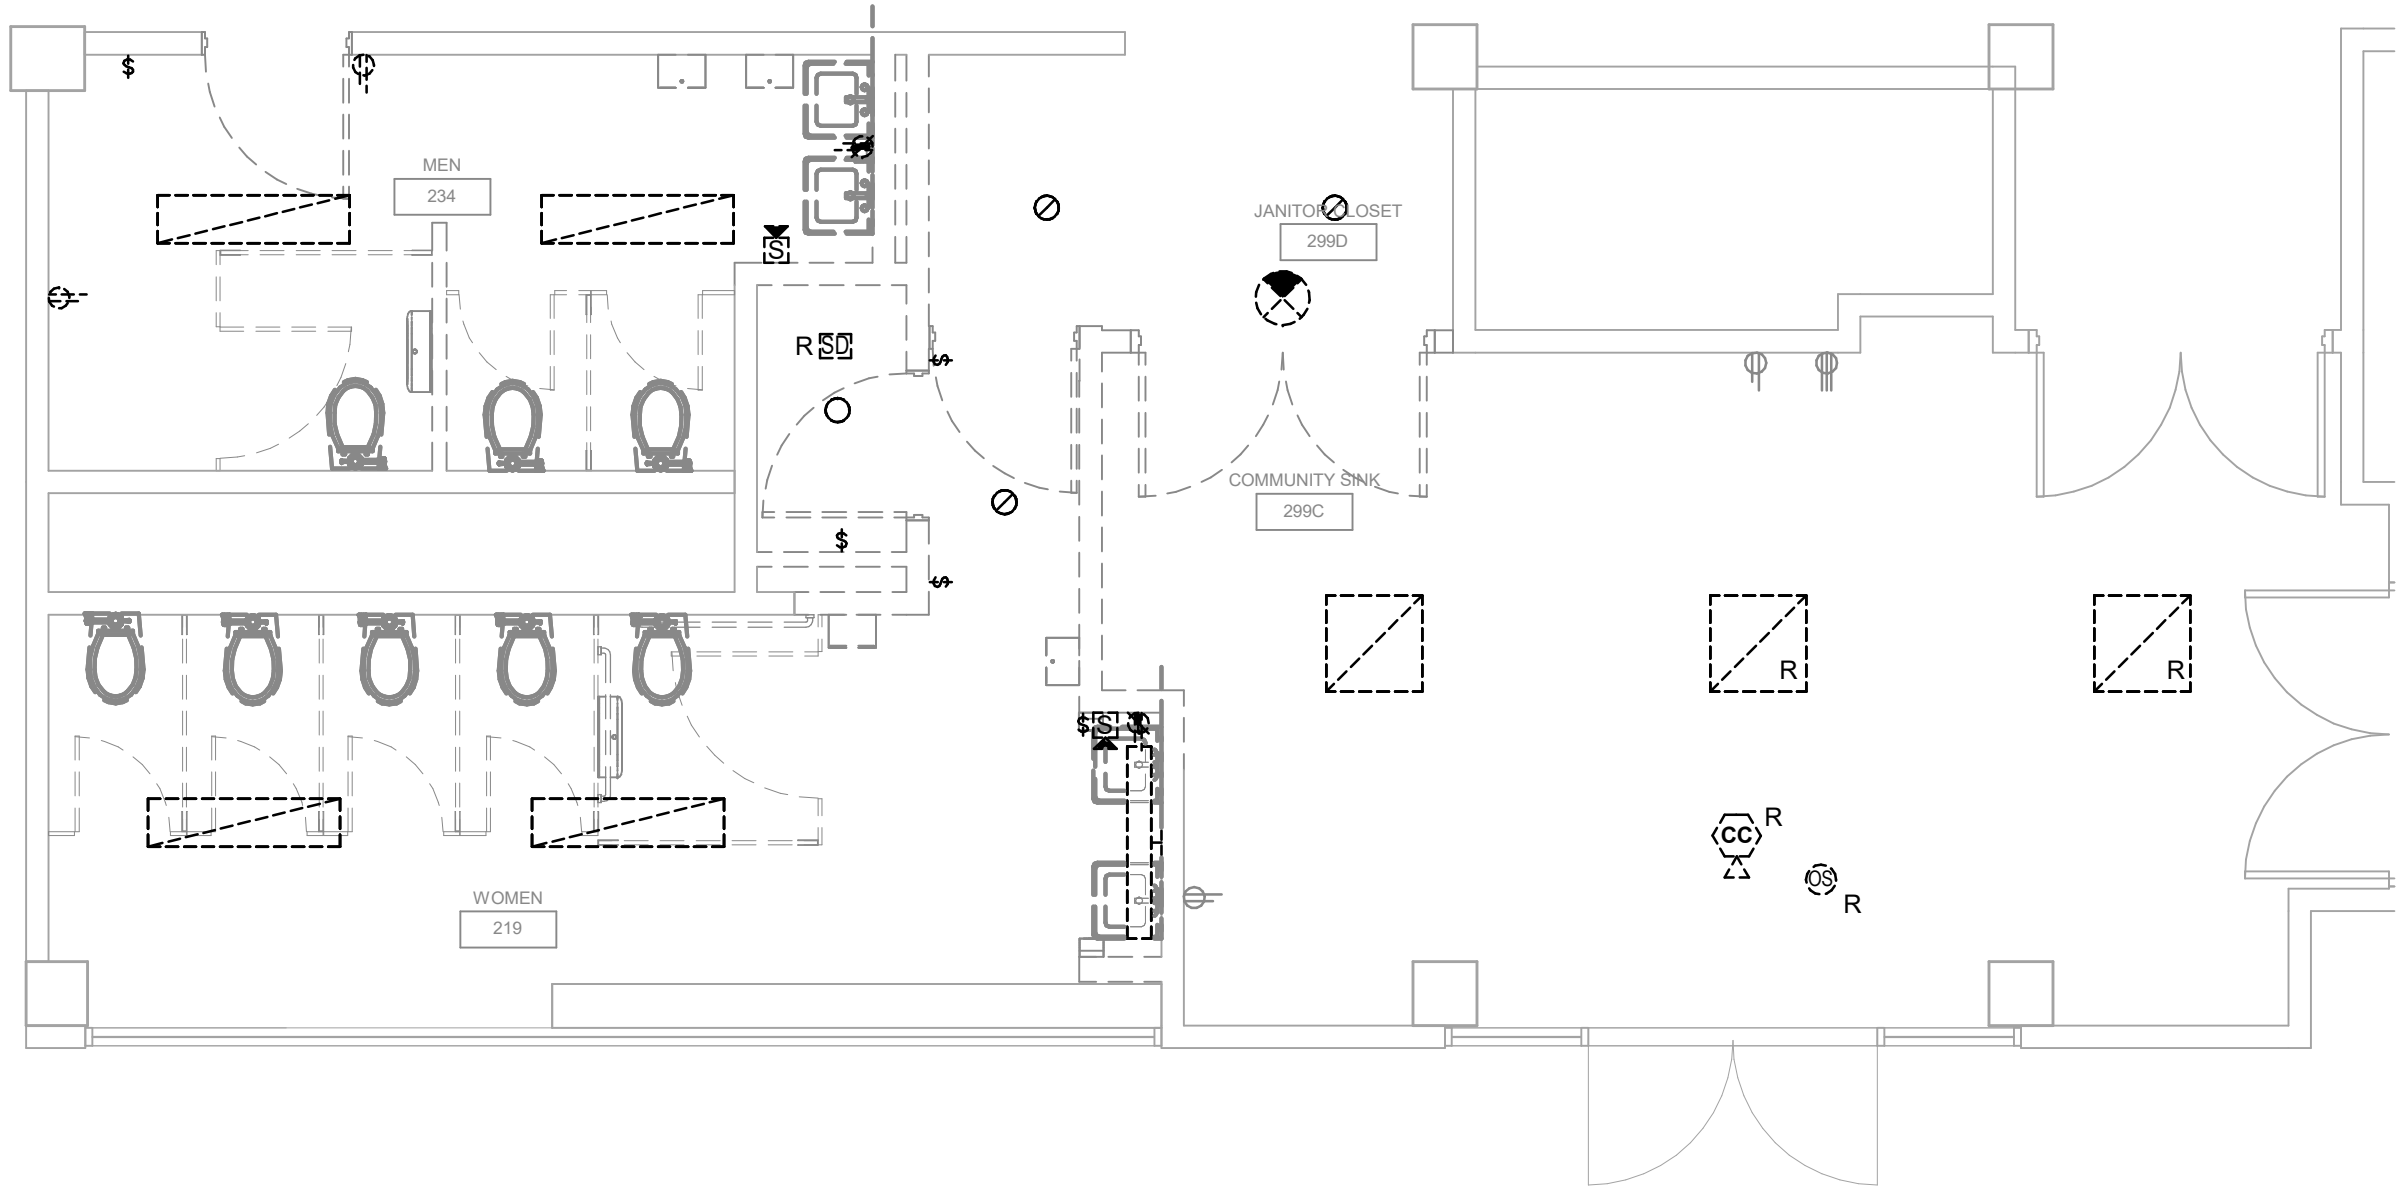


5 55B - SECOND FLOOR RESTROOMS - ELEC DEMO
1/4" = 1'-0"

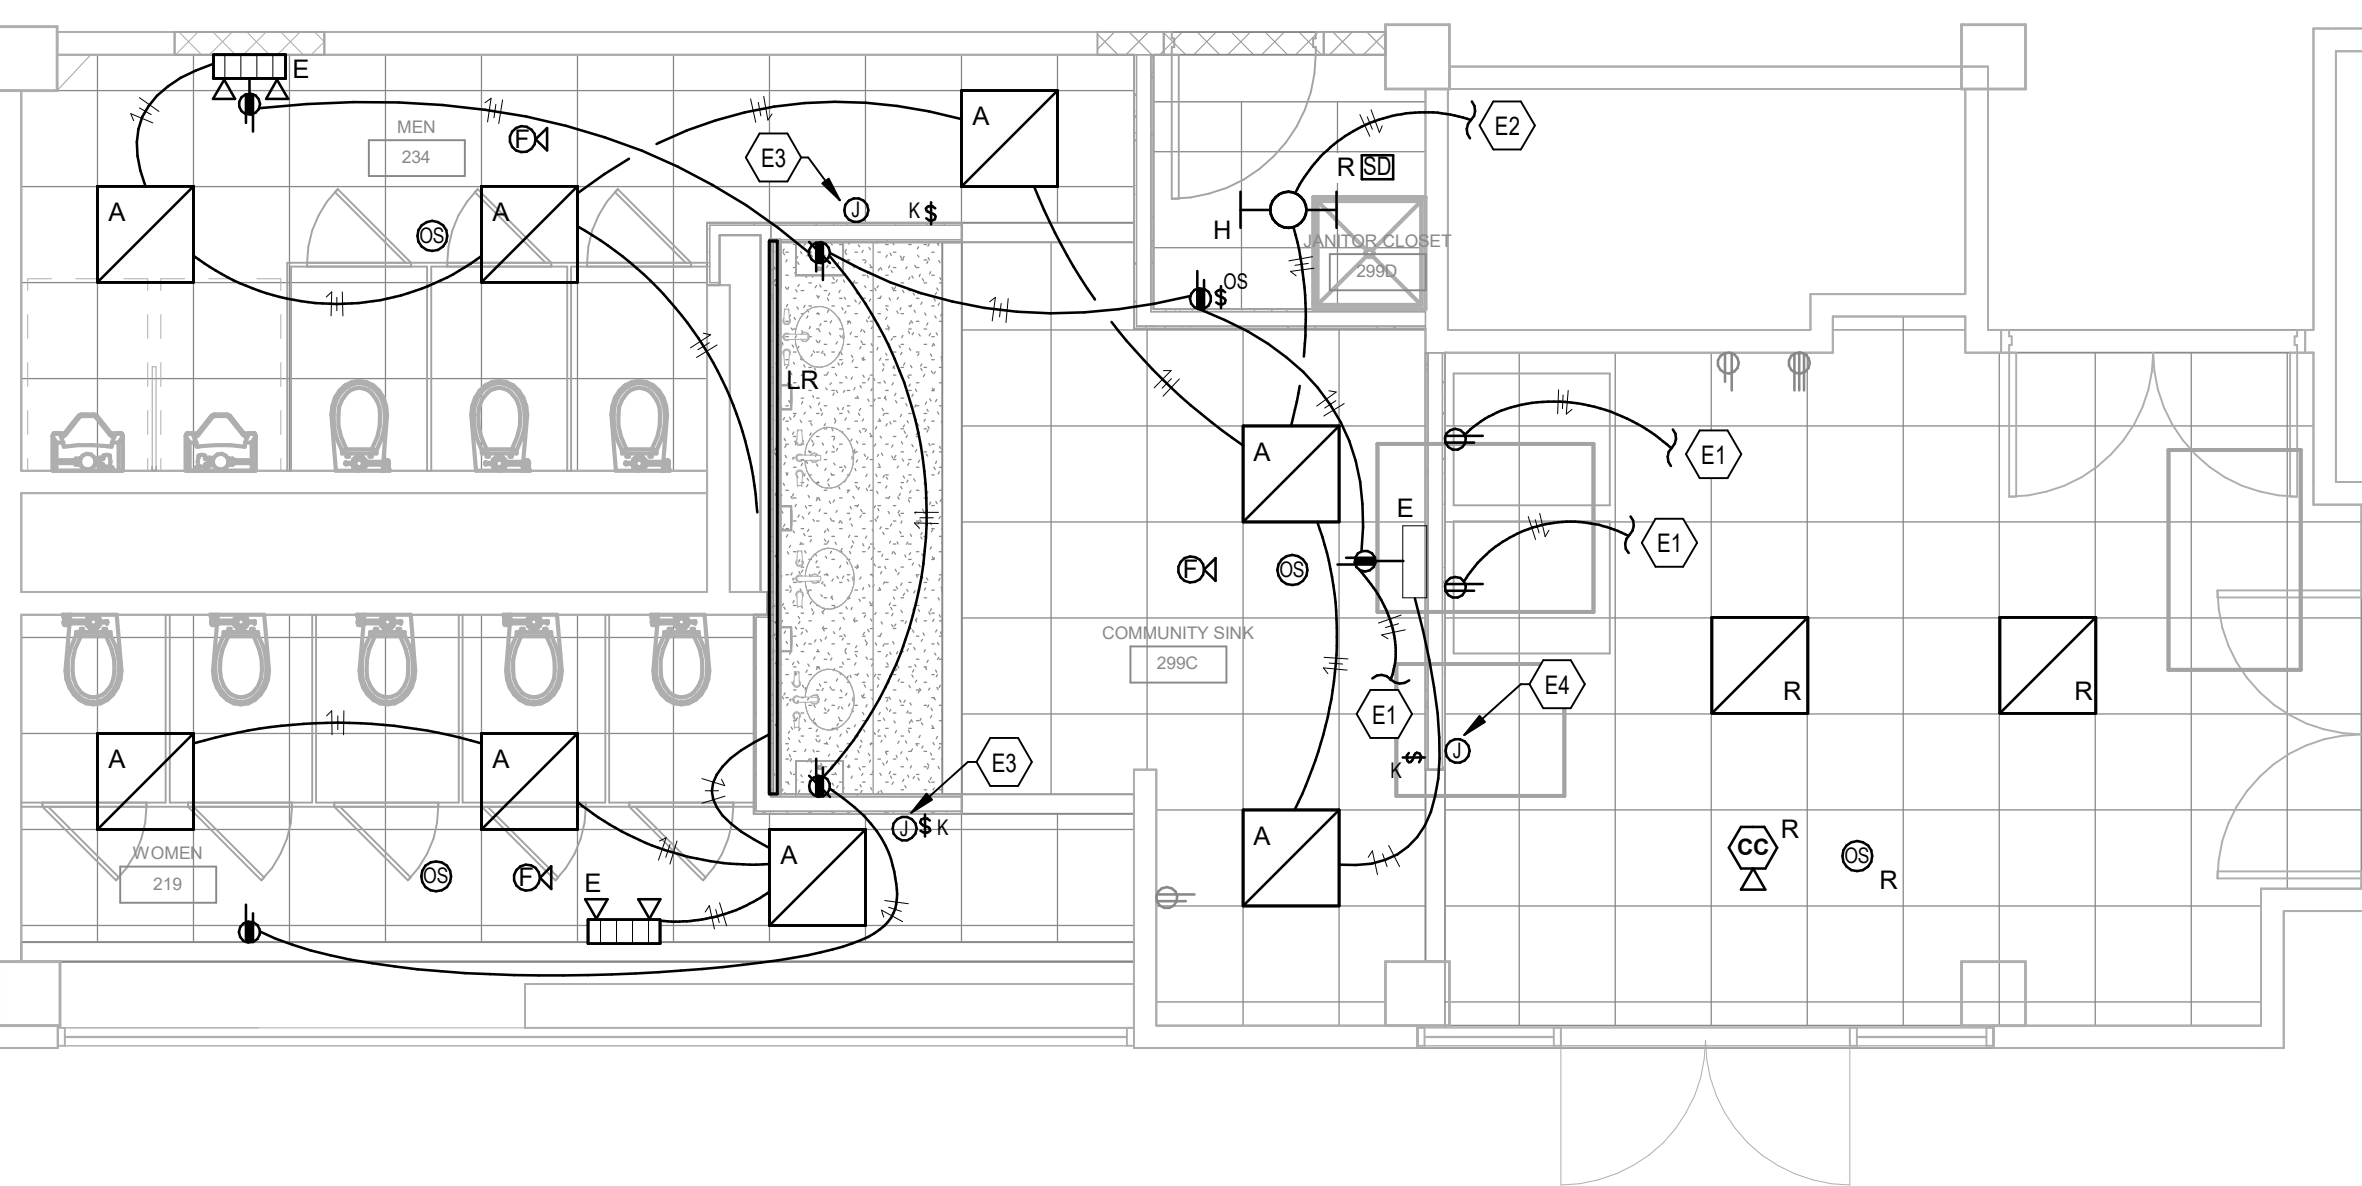


6 55B - SECOND FLOOR RESTROOMS - ELEC NEW
1/4" = 1'-0"

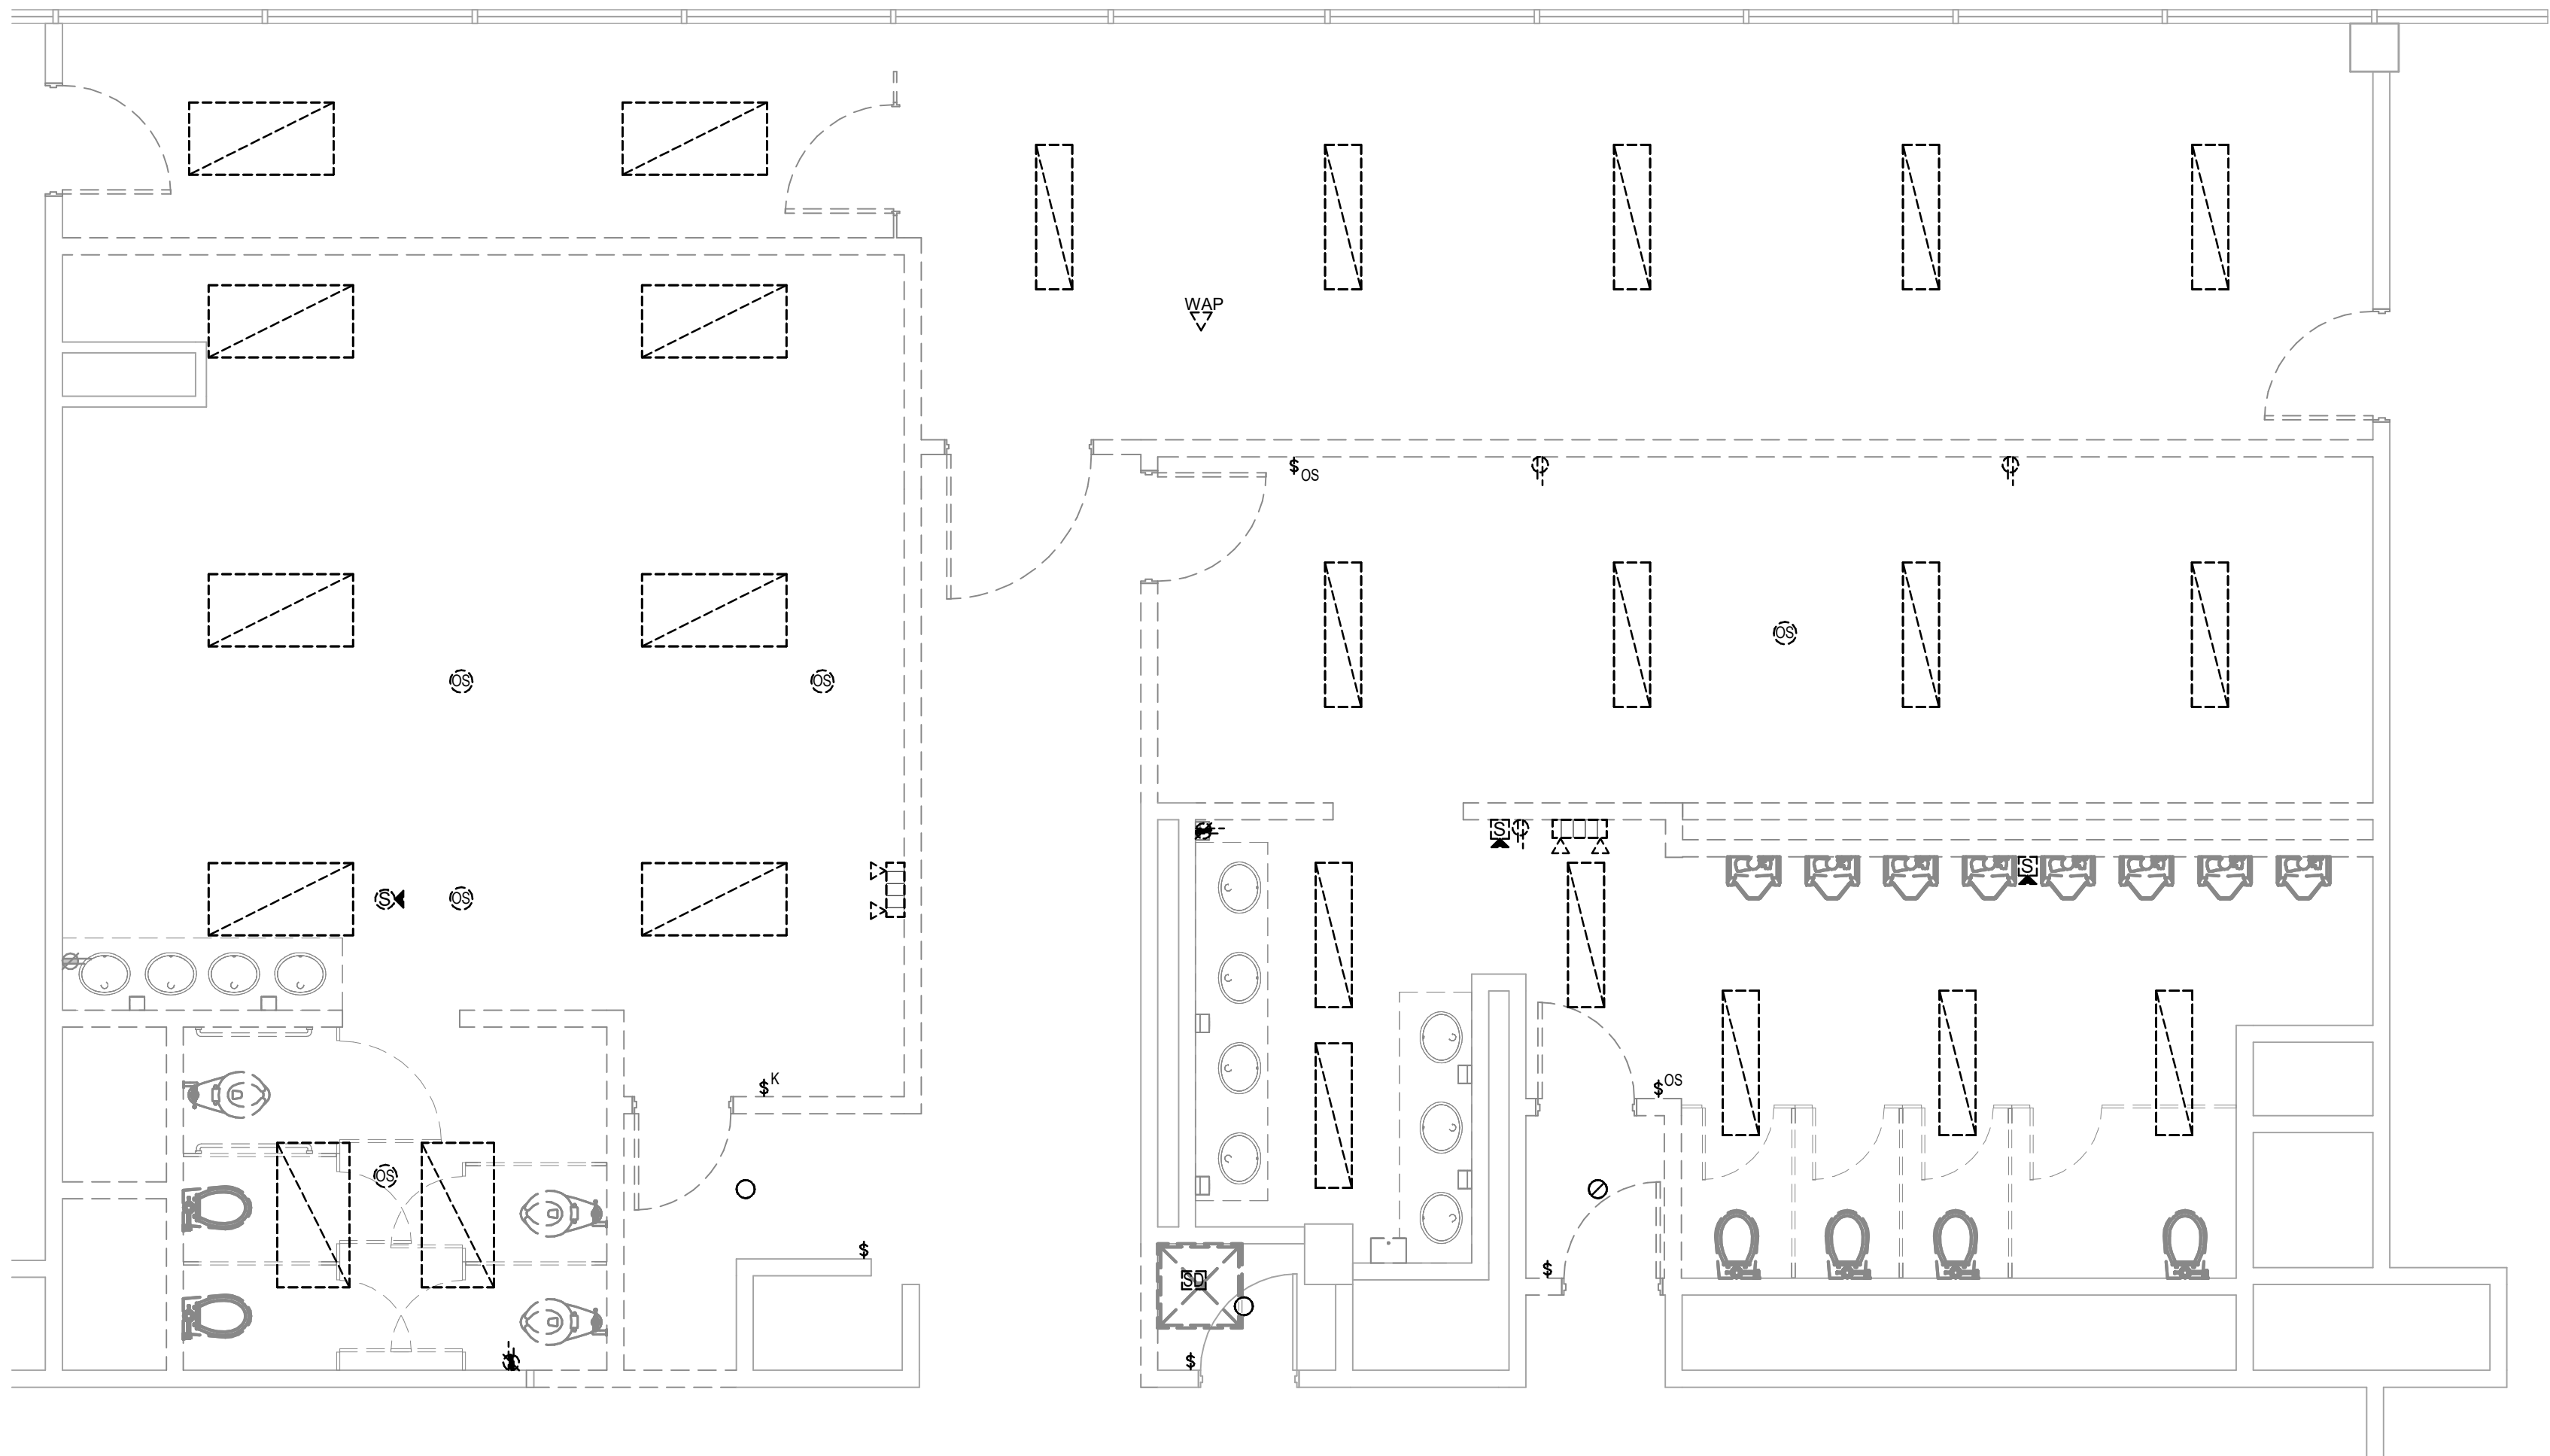

55B - THIRD FLOOR RESTROOMS - ELEC DEMO
1/4" = 1'-0"

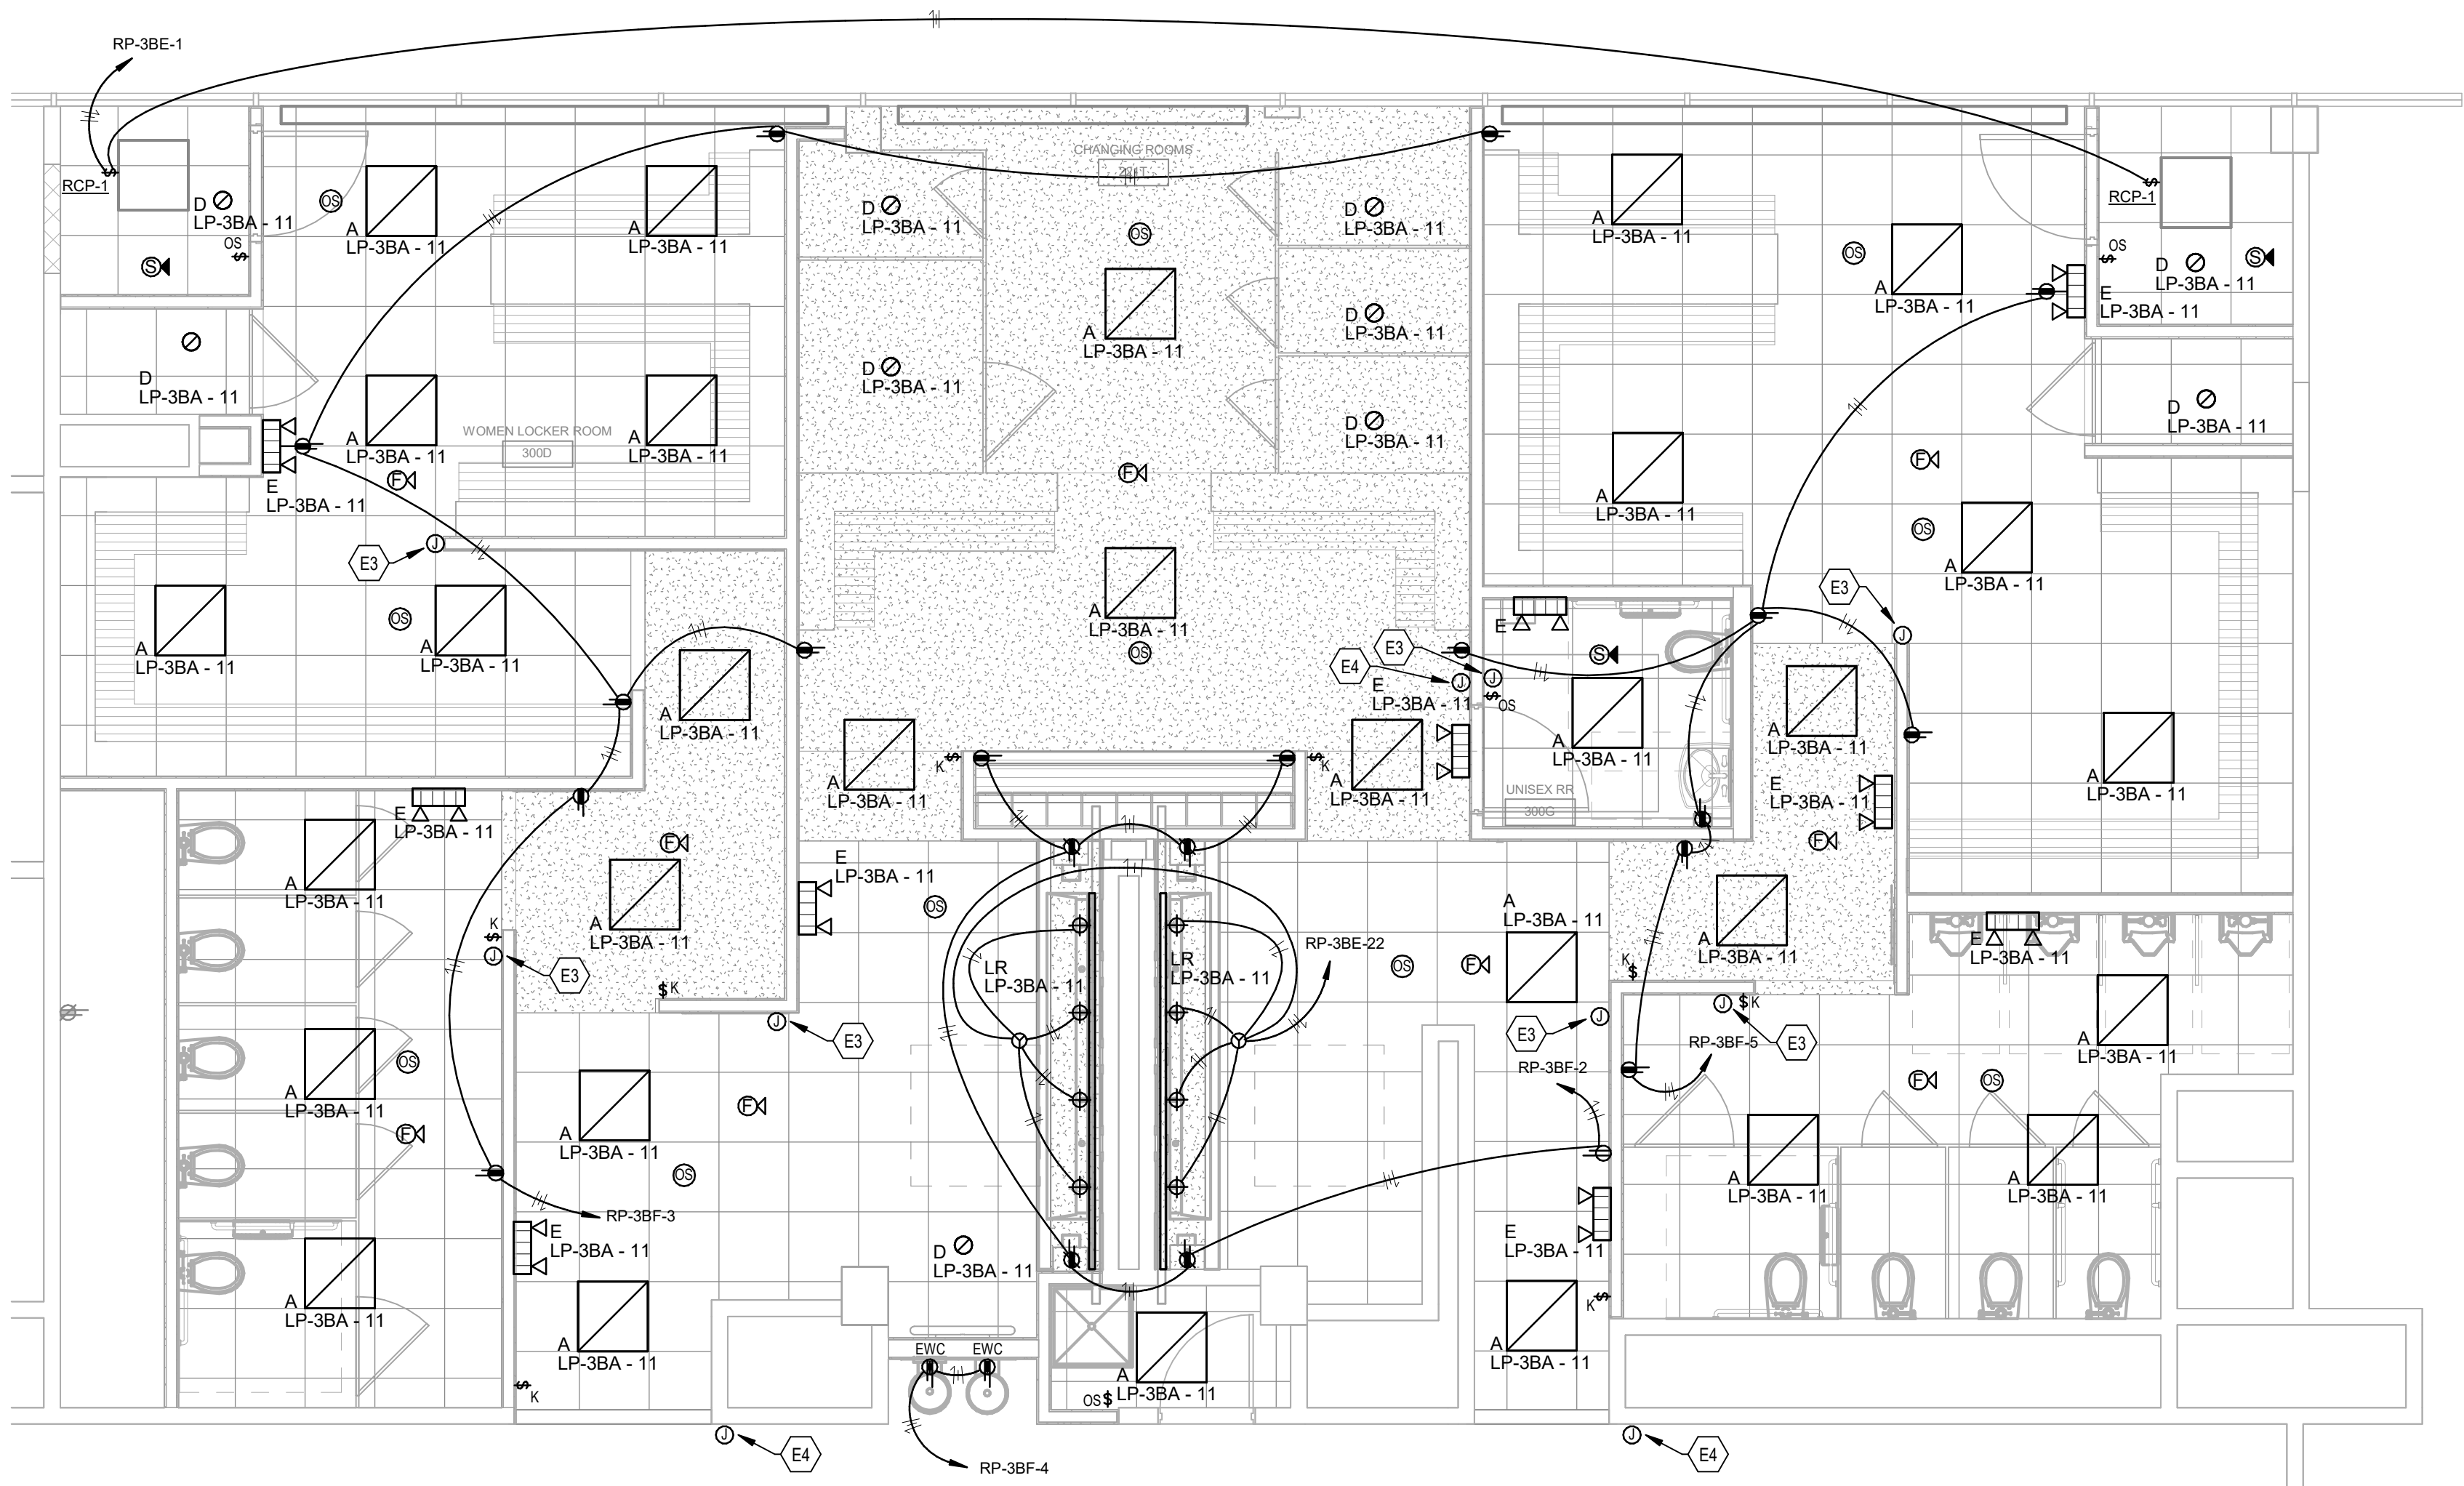

55B - THIRD FLOOR RESTROOMS - ELEC NEW
1/4" = 1'-0"

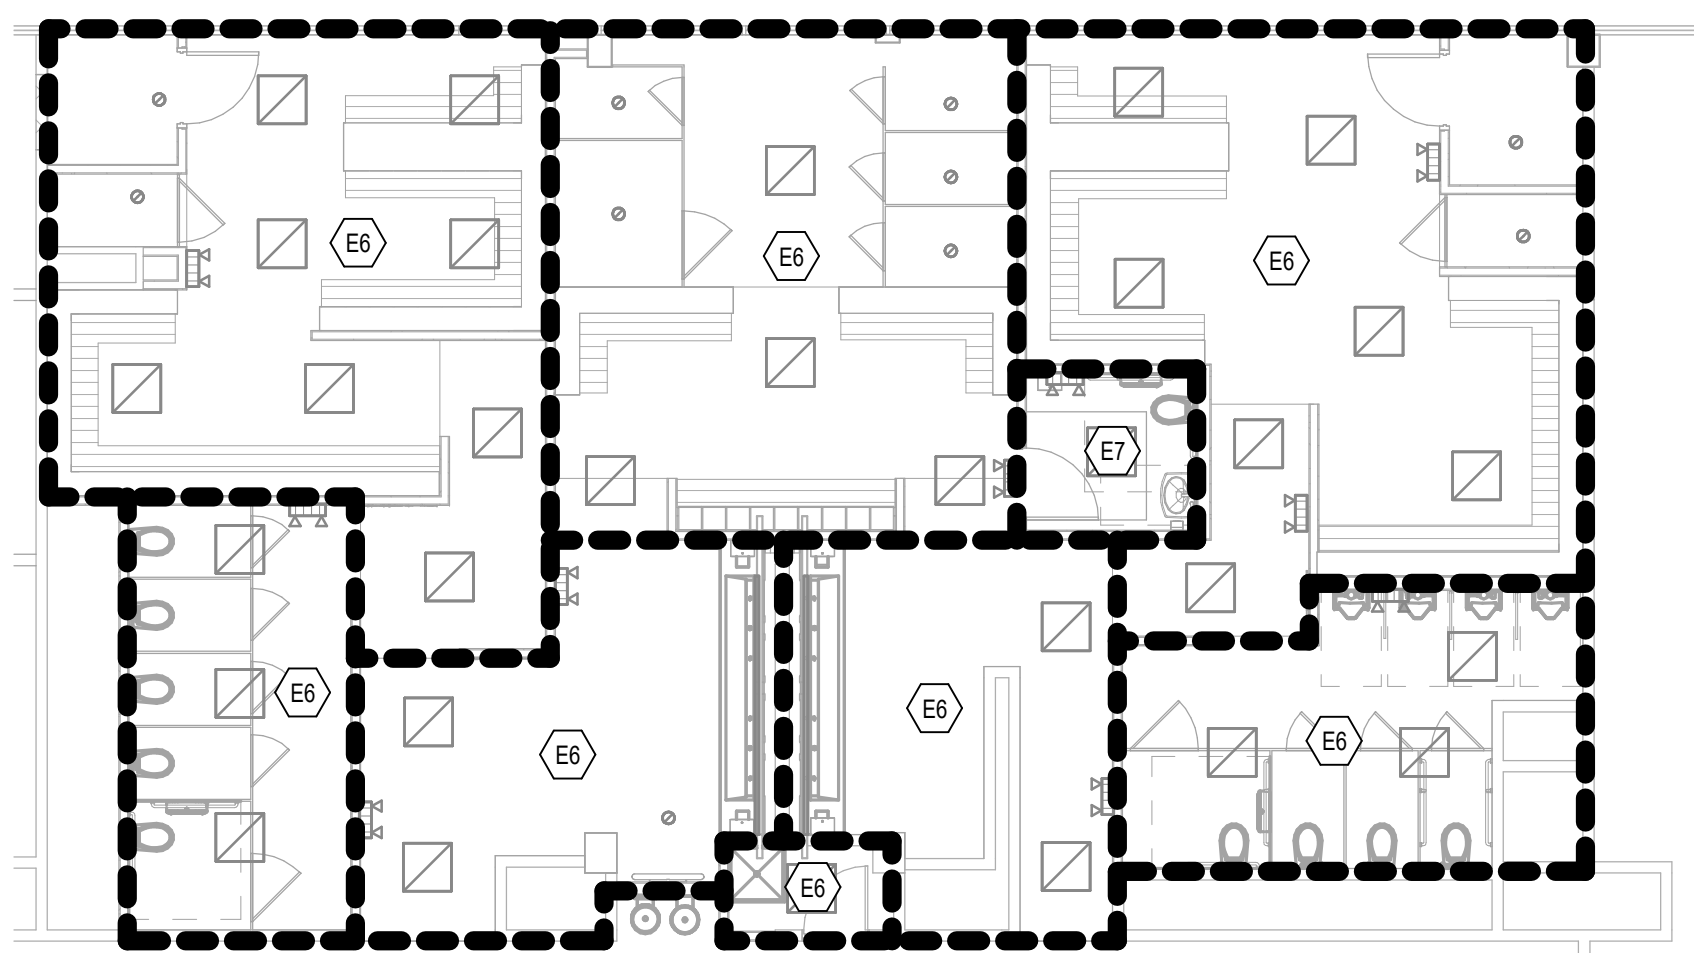

55B - THIRD FLOOR RESTROOMS - LIGHTING CONTROLS
1/8" = 1'-0"

GENERAL NOTES (ELECTRICAL NEW WORK):

- REFER TO THE ARCHITECT'S REFLECTED CEILING PLANS, ELEVATIONS, AND CASEWORK DETAILS FOR EXACT LOCATIONS OF ALL WALL AND CEILING MOUNTED ELECTRICAL DEVICES.
- CONTRACTOR SHALL FOLLOW BRANCH CIRCUITING LAY-OUT, AS INDICATED ON THE FLOOR PLANS, WITH A MAXIMUM OF THREE (3) BRANCH CIRCUITS PER HOMERUN. EACH BRANCH CIRCUIT SHALL BE PROVIDED WITH A DEDICATED NEUTRAL CONDUCTOR. DEDICATED NEUTRAL CONDUCTORS SHALL BE CONSIDERED CURRENT CARRYING. IF ADDITIONAL CONDUCTORS ARE RAN IN THE SAME CONDUIT WITH THOSE INDICATED, CONTRACTOR SHALL DERATE ALL CURRENT CARRYING CONDUCTORS PER N.E.C. #310.15(B)(3), AND UPSIZE CONDUIT AS REQUIRED PER N.E.C. #300.17 AND ANNEX C. MULTIWIRE BRANCH CIRCUITS AS DEFINED IN N.E.C. #100.2(1) 4 (CIRCUITS SHARING A COMMON NEUTRAL CONDUCTOR) SHALL NOT BE PERMITTED.
- IDENTIFY THE PANEL AND CIRCUIT NUMBER FOR ALL RECEPTACLES, SWITCHES, ETC. IN AREA OF CONSTRUCTION. PROVIDE CLEAR ADHESIVE LABELS WITH BLACK LETTERING; ALSO, MARK INSIDES OF ALL DEVICE BOXES WITH PANEL AND CIRCUIT NUMBER.
- LOCATE CHAIN-HUNG INDUSTRIAL FIXTURES IN MECHANICAL ROOMS TO AVOID DUCTWORK AND PIPING. TO MAXIMIZE AVAILABLE LIGHT SPACE AROUND EQUIPMENT, AIR HANDLERS, ETC. TO PROVIDE ADEQUATE LIGHTING TO ALL AREAS OF ROOM. PROVIDE ADDITIONAL FIXTURES OF SAME TYPE AS NEEDED TO FULFILL THIS REQUIREMENT.
- LOCATE EXIT SIGNS FOR MAXIMUM VIEWING AREA TO IDENTIFY EGRESS PATHS AS INDICATED ON PLANS. COORDINATE LOCATIONS SUCH THAT ARCHITECTURAL FEATURES OR EQUIPMENT FROM OTHER TRADES DO NOT OBSTRUCT VIEW.
- ALL LIGHTING FIXTURE LENSES, PARABOLIC LOUVERS, DOWNLIGHTING ALZAK CONES AND "PARACUBE" LOUVERS SHALL BE HANDLED WITH COTTON GLOVES DURING INSTALLATION AND LAMPING TO AVOID FINGERPRINTS OR DIRT DEPOSITS. IT IS PREFERRED THAT FIXTURES BE SHIPPED AND INSTALLED WITH CLEAR PLASTIC BAGS TO PROTECT LOUVERS. AT CLOSE OF PROJECT, AND AFTER CONSTRUCTION AIR FILTERS ARE CHANGED, REMOVE BAGS. ANY LOUVER OR CONE SHOWING DIRT OR FINGER PRINTS SHALL BE CLEANED WITH SOLVENT RECOMMENDED BY THE MANUFACTURER, OR REPLACED AS NECESSARY IN ORDER TO TURN OVER TO THE OWNER NEW FIXTURES AT OCCUPANCY.
- RECESSED LUMINAIRES SHALL BE SECURED SUCH THAT THE FORCE REQUIRED INSERTING LAMPS, TRIMS, LENSES, LOUVERS, OR DOOR FRAMES DOES NOT SHIFT HOUSING. ALL TRIMS SHALL BE COMPLETELY FLUSH WITH FINISHED CEILINGS AT COMPLETION OF CONSTRUCTION.
- CONTRACTOR SHALL PROVIDE UNSWITCHED CONDUCTOR TO ALL EXIT SIGNS, EMERGENCY INVERTER BATTERY PACKS, AND NIGHT LIGHTS AS REQUIRED.
- RECEPTACLES THAT ARE CONTROLLED BY AN AUTOMATIC MEANS SUCH AS OCCUPANCY SENSOR OR ENERGY MANAGEMENT SYSTEM SHALL BE MARKED IN ACCORDANCE WITH NEC 405.3(E).
- LOCATIONS OF ELECTRICAL CONNECTIONS AND LOCAL DISCONNECTS SHALL BE COORDINATED WITH MECHANICAL AND PLUMBING CONTRACTORS TO ENSURE ACCESS AND WORKING CLEARANCE IS MAINTAINED PER NEC. NOTIFY OTHER TRADES OF REQUIRED CLEARANCE AREAS TO AVOID ROUTING OF OTHER SYSTEMS IN THESE AREAS. DO NOT INSTALL ELECTRICAL EQUIPMENT OVER EQUIPMENT NAMEPLATES OR ACCESS PANELS OR THROUGH ACCESS/MAINTENANCE CLEARANCES OF EQUIPMENT BY OTHER TRADES.
- EXISTING TO REMAIN DEVICES/FACEPLATES SHALL BE REPLACED AS NECESSARY FOR NEW ARCHITECTUAL FINISHES.

ELECTRICAL KEYNOTES

- PROVIDE NEW BACKBOX, AND RACEWAY WITH PULLSTRING TO NEW POLICE CALL PULL STATION. COORDINATE EXACT REQUIREMENTS WITH UOPL.
- PROVIDE NEW BACKBOX, AND RACEWAY WITH PULLSTRING TO NEW POLICE CALL SOUNDER STATION LOCATION. COORDINATE EXACT REQUIREMENTS WITH UOPL.
- WALL SWITCH, AND OCCUPANCY SENSORS SHALL CONTROL FIXTURES. AUTO ON/AUTO OFF.
- WALL SWITCH, AND VACANCY SENSORS SHALL CONTROL FIXTURES. MANUAL ON/AUTO OFF.

UofL HSC RESTROOM RENOVATIONS

CONSTRUCTION DOCUMENTS

REVISIONS		
#	DATE	DESCRIPTION
2	1/27/25	ADDENDUM 2



PROJECT TEAM

EOP ARCHITECTS
PRIME ARCHITECT
322 EAST MAIN STREET
LOUISVILLE, KY 40202
p. 859-231-7538 | f. 859-255-4380
www.eopa.com


CMTA, INC.
10411 MEETING STREET
PROSPECT, KY 40059
p. 502-326-3085
www.cmta.com

All designs, arrangements and plans indicated or represented by this drawing are the property of EOP Architects and were created and developed for use on and in connection with the specified project.

None of this information shall be used by or disclosed to any person or entity for any reason whatsoever without the permission of EOP Architects.

Written dimensions shall have precedence over scale dimensions. Contractor shall verify and be responsible for all dimensions and conditions on the job. Notify EOP Architects immediately of any variation from the dimensions and conditions shown by these drawings.


Job Number 497-8933
Drawn By ZTS
Checked By DDY
Date 2024/12/18

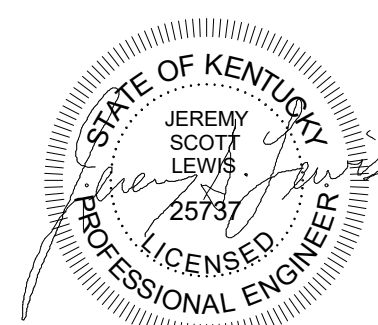


ENLARGED RESTROOM PLANS

55B-E101


E
D
C
B
A

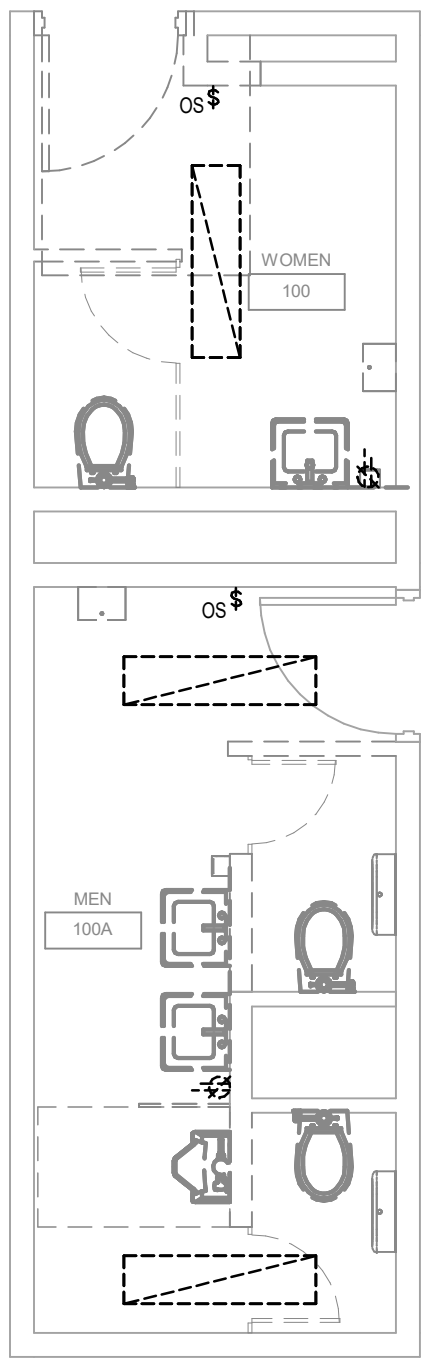


1 55A - FIRST FLOOR RESTROOMS - ELEC DEMO
1/4" = 1'-0"

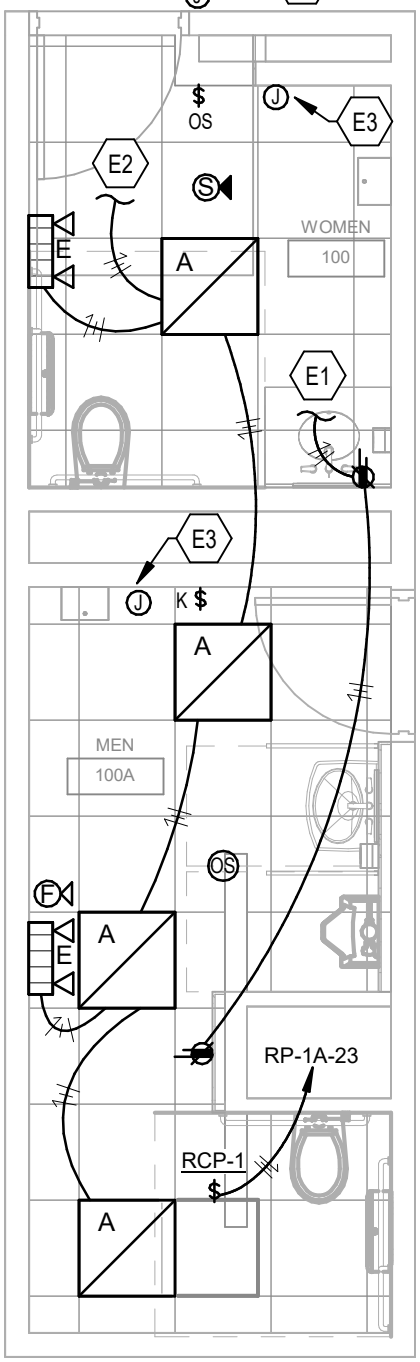


2 55A - FIRST FLOOR RESTROOMS - ELEC NEW
1/4" = 1'-0"

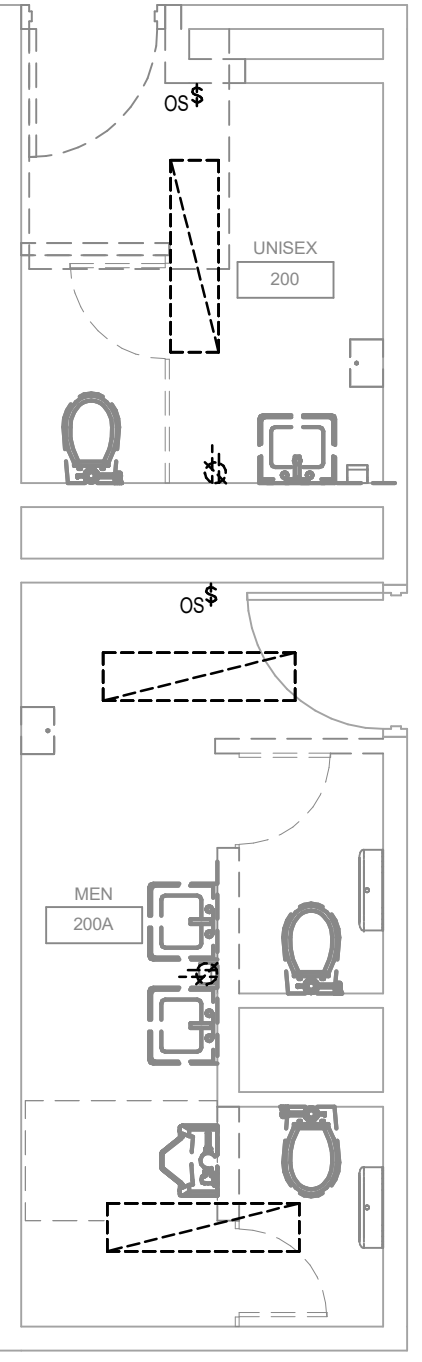


3 55A - SECOND FLOOR RESTROOMS - ELEC DEMO
1/4" = 1'-0"

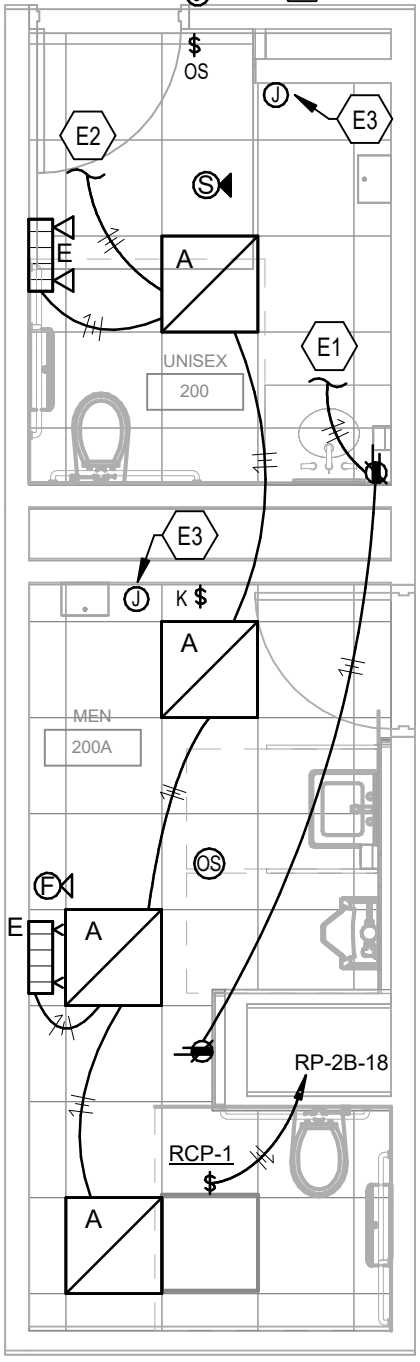

4 55A - SECOND FLOOR RESTROOMS - ELEC NEW
1/4" = 1'-0"

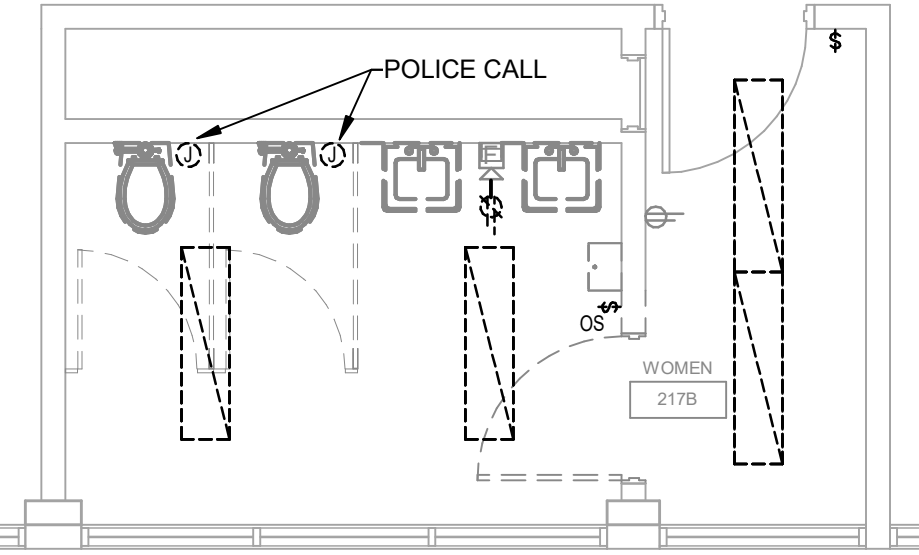

5 55A - SECOND FLOOR - WOMEN RESTROOM - ELEC DEMO
1/4" = 1'-0"

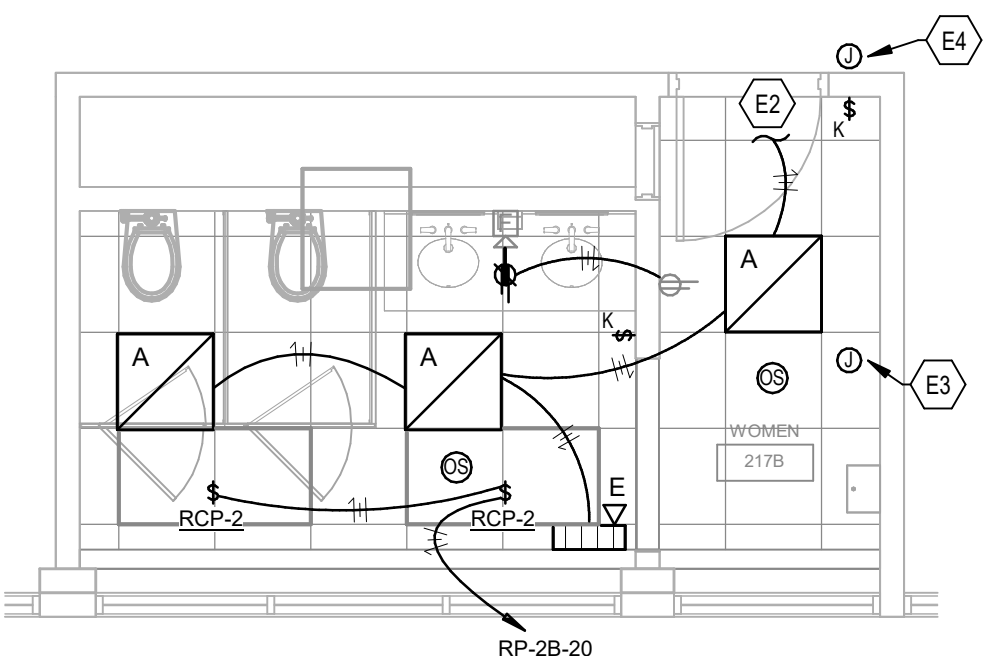

6 55A - SECOND FLOOR - WOMEN RESTROOM - ELEC NEW
1/4" = 1'-0"

GENERAL NOTES (ELECTRICAL NEW WORK):

- A. REFER TO THE ARCHITECT'S REFLECTED CEILING PLANS, ELEVATIONS, AND CASEWORK DETAILS FOR EXACT LOCATIONS OF ALL WALL AND CEILING MOUNTED ELECTRICAL DEVICES.
- B. CONTRACTOR SHALL FOLLOW BRANCH CIRCUITING LAY-OUT AS INDICATED ON THE FLOOR PLANS, WITH A MAXIMUM OF THREE (3) BRANCH CIRCUITS PER HOMERUN. EACH BRANCH CIRCUIT SHALL BE PROVIDED WITH A DEDICATED NEUTRAL CONDUCTOR. DEDICATED NEUTRAL CONDUCTORS SHALL BE CONSIDERED CURRENT CARRYING. IF ADDITIONAL CONDUCTORS ARE RAN IN THE SAME CONDUIT WITH THOSE INDICATED, CONTRACTOR SHALL DERATE ALL CURRENT CARRYING CONDUCTORS PER N.E.C. #510.16(B)(3), AND UPSIZE CONDUIT AS REQUIRED PER N.E.C. #300.17 AND ANNEX C. MULTIWIRE BRANCH CIRCUITS AS DEFINED IN N.E.C. #100.2(1) 210.4 (CIRCUITS SHARING A COMMON NEUTRAL CONDUCTOR) SHALL NOT BE PERMITTED.
- C. IDENTIFY THE PANEL AND CIRCUIT NUMBER FOR ALL RECEPTACLES, SWITCHES, ETC. IN AREA OF CONSTRUCTION. PROVIDE CLEAR ADHESIVE LABELS WITH BLACK LETTERING; ALSO, MARK INSIDES OF ALL DEVICE BOXES WITH PANEL AND CIRCUIT NUMBER.
- D. LOCATE CHAIN-HUNG INDUSTRIAL FIXTURES IN MECHANICAL ROOMS TO AVOID DUCTWORK AND PIPING. TO MAXIMIZE AVAILABLE LIGHT SPACE AROUND EQUIPMENT, AIR HANDLERS, ETC. TO PROVIDE ADEQUATE LIGHTING TO ALL AREAS OF ROOM. PROVIDE ADDITIONAL FIXTURES OF SAME TYPE AS NEEDED TO FULFILL THIS REQUIREMENT.
- E. LOCATE EXIT SIGNS FOR MAXIMUM VIEWING AREA TO IDENTIFY EGRESS PATHS AS INDICATED ON PLANS. COORDINATE LOCATIONS SUCH THAT ARCHITECTURAL FEATURES OR EQUIPMENT FROM OTHER TRADES DO NOT OBSTRUCT VIEW.
- F. ALL LIGHTING FIXTURE LENSES, PARABOLIC LOUVERS, DOWNLIGHTING ALZAK CONES AND "PARACUBE" LOUVERS SHALL BE HANDLED WITH COTTON GLOVES DURING INSTALLATION AND LAMPING TO AVOID FINGERPRINTS OR DIRT DEPOSITS. IT IS PREFERRED THAT FIXTURES BE SHIPPED AND INSTALLED WITH CLEAR PLASTIC BAGS TO PROTECT LOUVERS AT CLOSE OF PROJECT. AND AFTER CONSTRUCTION AIR FILTERS ARE CHANGED, REMOVE BAGS. ANY LOUVER OR CONE SHOWING DIRT OR FINGER PRINTS SHALL BE CLEANED WITH SOLVENT RECOMMENDED BY THE MANUFACTURER, OR REPLACED AS NECESSARY IN ORDER TO TURN OVER TO THE OWNER NEW FIXTURES AT OCCUPANCY.
- G. RECESSED LUMINAIRES SHALL BE SECURED SUCH THAT THE FORCE REQUIRED INSERTING LAMPS, TRIMS, LENSES, LOUVERS, OR DOOR FRAMES DOES NOT SHIFT HOUSING. ALL TRIMS SHALL BE COMPLETELY FLUSH WITH FINISHED CEILINGS AT COMPLETION OF CONSTRUCTION.
- H. CONTRACTOR SHALL PROVIDE UNSWITCHED CONDUCTOR TO ALL EXIT SIGNS, EMERGENCY INVERTER BATTERY PACKS, AND NIGHT LIGHTS AS REQUIRED.
- I. RECEPTACLES THAT ARE CONTROLLED BY AN AUTOMATIC MEANS SUCH AS OCCUPANCY SENSOR OR ENERGY MANAGEMENT SYSTEM SHALL BE MARKED IN ACCORDANCE WITH NEC 405.3(E).
- J. LOCATIONS OF ELECTRICAL CONNECTIONS AND LOCAL DISCONNECTS SHALL BE COORDINATED WITH MECHANICAL AND PLUMBING CONTRACTORS TO ENSURE ACCESS AND WORKING CLEARANCE IS MAINTAINED PER NEC. NOTIFY OTHER TRADES OF REQUIRED CLEARANCE AREAS TO AVOID ROUTING OF OTHER SYSTEMS IN THESE AREAS. DO NOT INSTALL ELECTRICAL EQUIPMENT OVER EQUIPMENT NAMEPLATES OR ACCESS PANELS OR THROUGH ACCESS/MAINTENANCE CLEARANCES OF EQUIPMENT BY OTHER TRADES.
- K. EXISTING TO REMAIN DEVICES/FACEPLATES SHALL BE REPLACED AS NECESSARY FOR NEW ARCHITECTUAL FINISHES.

ELECTRICAL KEYNOTES

- E1 ROUTE # OF #12 CONDUCTORS IN 3/4" CONDUIT TO EXISTING RECEPTACLE CIRCUIT SERVING THIS AREA.
- E2 ROUTE # OF #12 CONDUCTORS IN 3/4" CONDUIT TO EXISTING LIGHTING CIRCUIT SERVING THIS AREA.
- E3 PROVIDE NEW BACKBOX, AND RACEWAY WITH PULLSTRING TO NEW POLICE CALL FULL STATION. COORDINATE EXACT REQUIREMENTS WITH UOFL.
- E4 PROVIDE NEW BACKBOX, AND RACEWAY WITH PULLSTRING TO NEW POLICE CALL SOUNDER STATION LOCATION. COORDINATE EXACT REQUIREMENTS WITH UOFL.

UoFL HSC
RESTROOM
RENOVATIONS

CONSTRUCTION
DOCUMENTS

REVISIONS		
#	DATE	DESCRIPTION
2	1/27/25	ADDENDUM 2



PROJECT TEAM

EOP ARCHITECTS
PRIME ARCHITECT
322 EAST MAIN STREET
LOUISVILLE, KY 40202
p. 859-231-7538 | f. 859-255-4380
www.eopa.com


CMTA, INC.
10411 MEETING STREET
PROSPECT, KY 40059
p. 502-326-3085
www.cmta.com

All designs, arrangements and plans indicated or represented by this drawing are the property of EOP Architects and were created and developed for use on and in connection with the specified project.

None of this information shall be used by or disclosed to any person or entity for any reason whatsoever without the permission of EOP Architects.

Written dimensions shall have precedence over scale dimensions. Contractor shall verify and be responsible for all dimensions and conditions on the job. Notify EOP Architects immediately of any variation from the dimensions and conditions shown by these drawings.

Job Number 497-8933
Drawn By ZTS
Checked By DDY
Date 2024/12/18

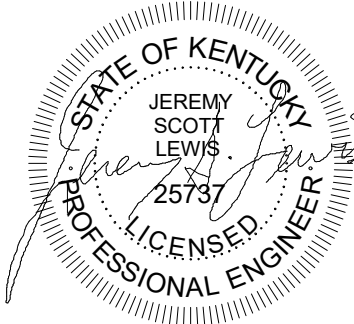

ENLARGED
RESTROOM PLANS

55A-E100